


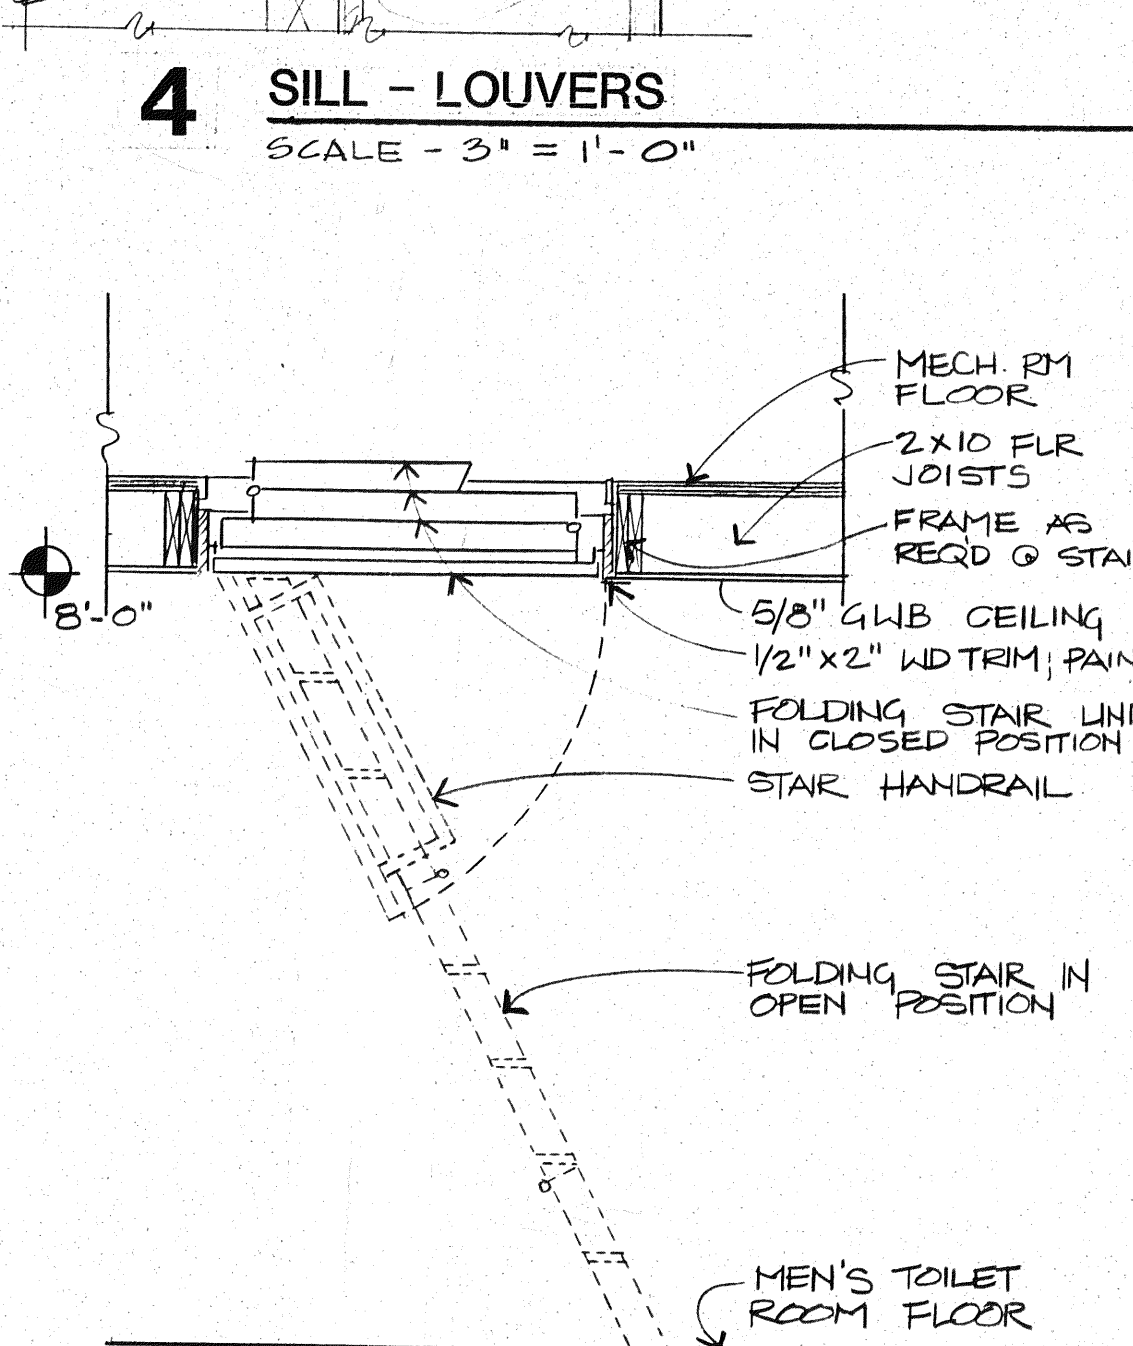
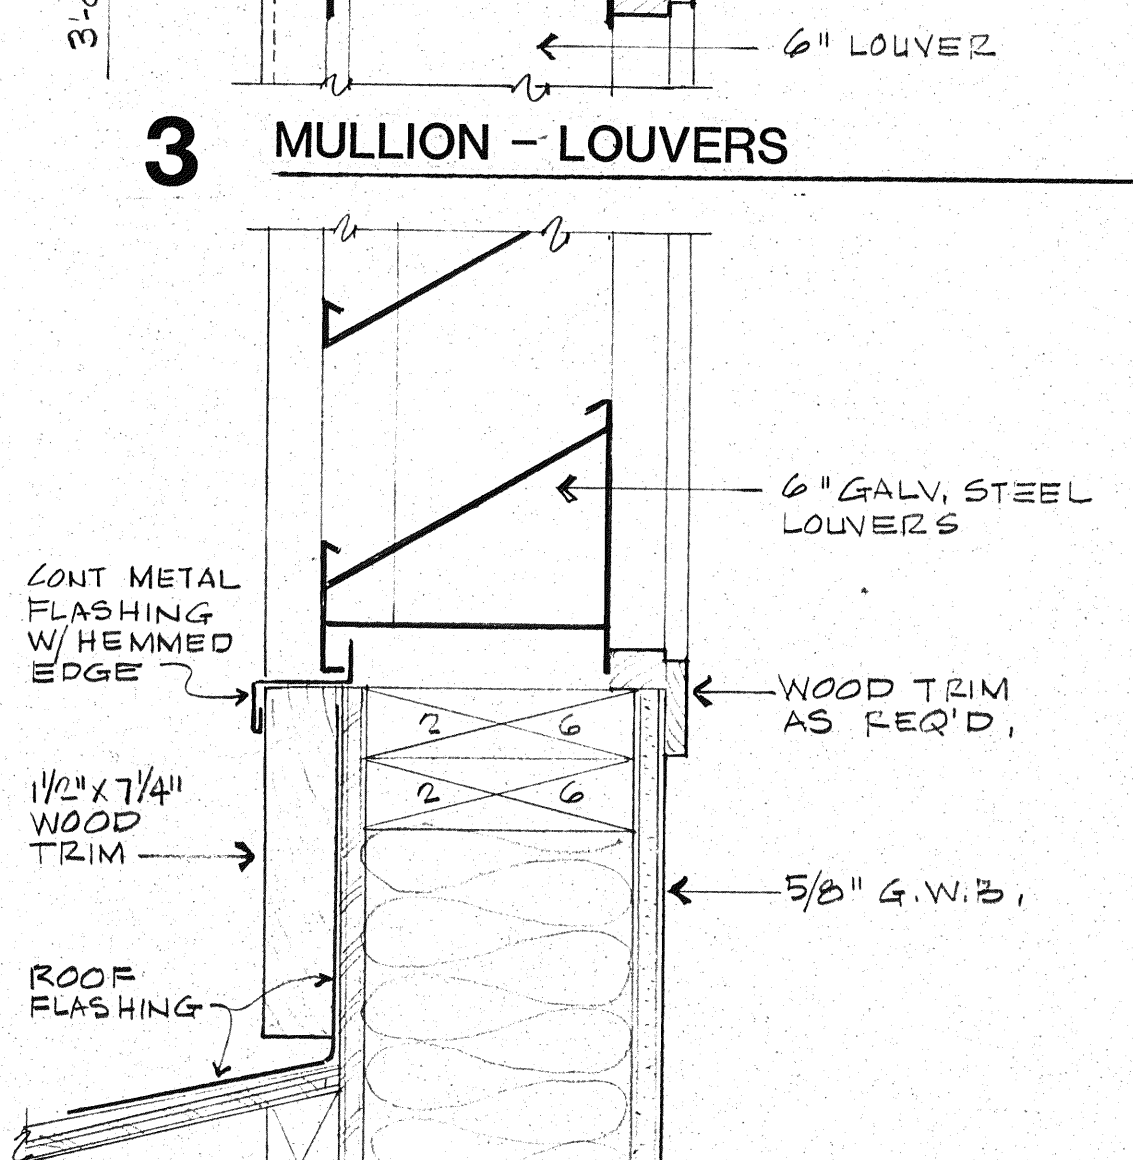
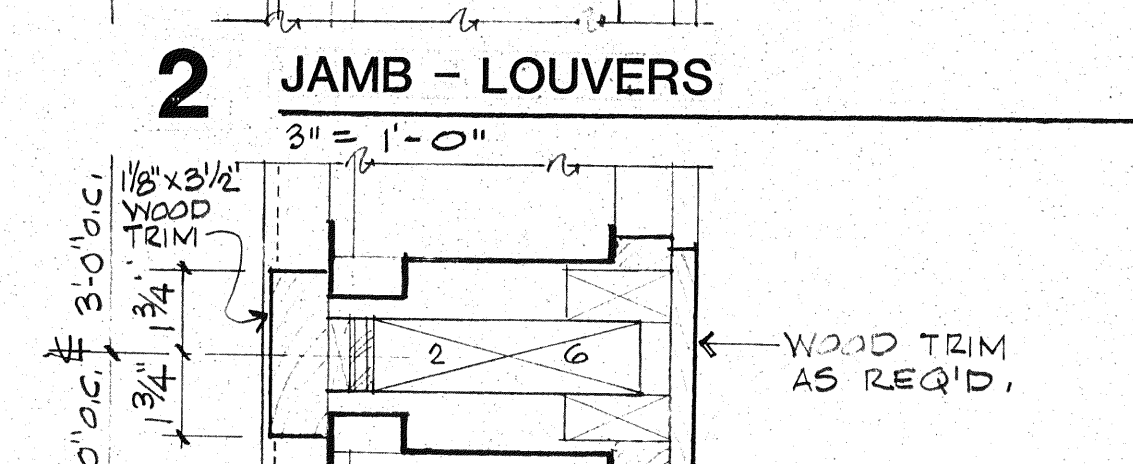
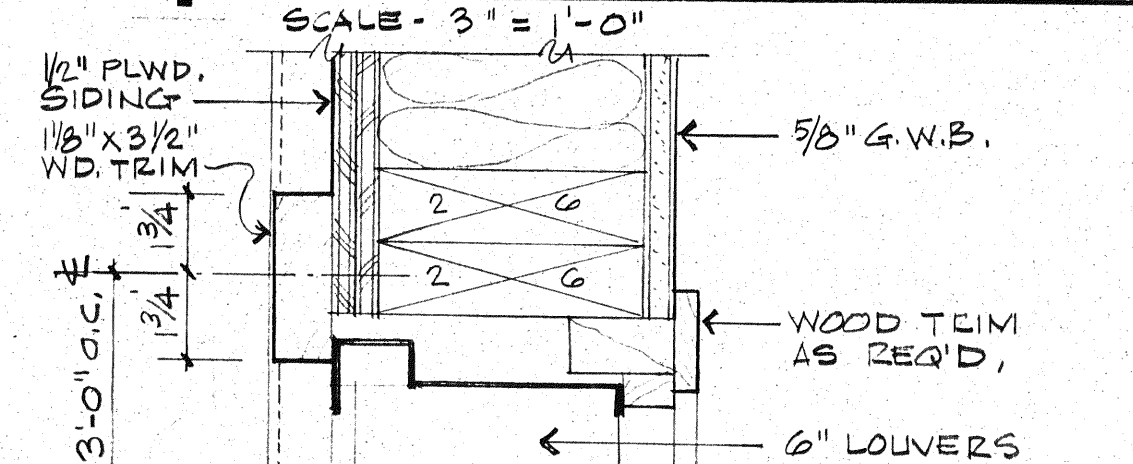
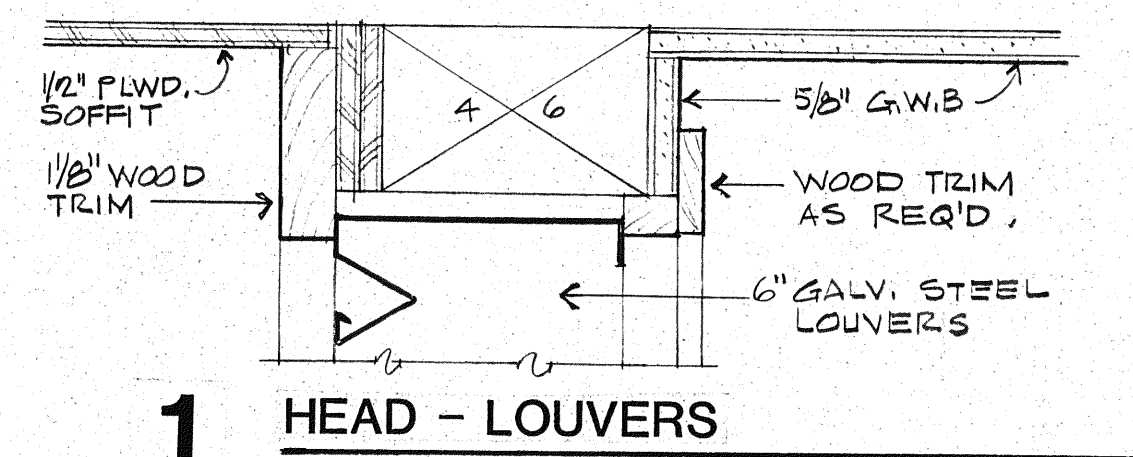
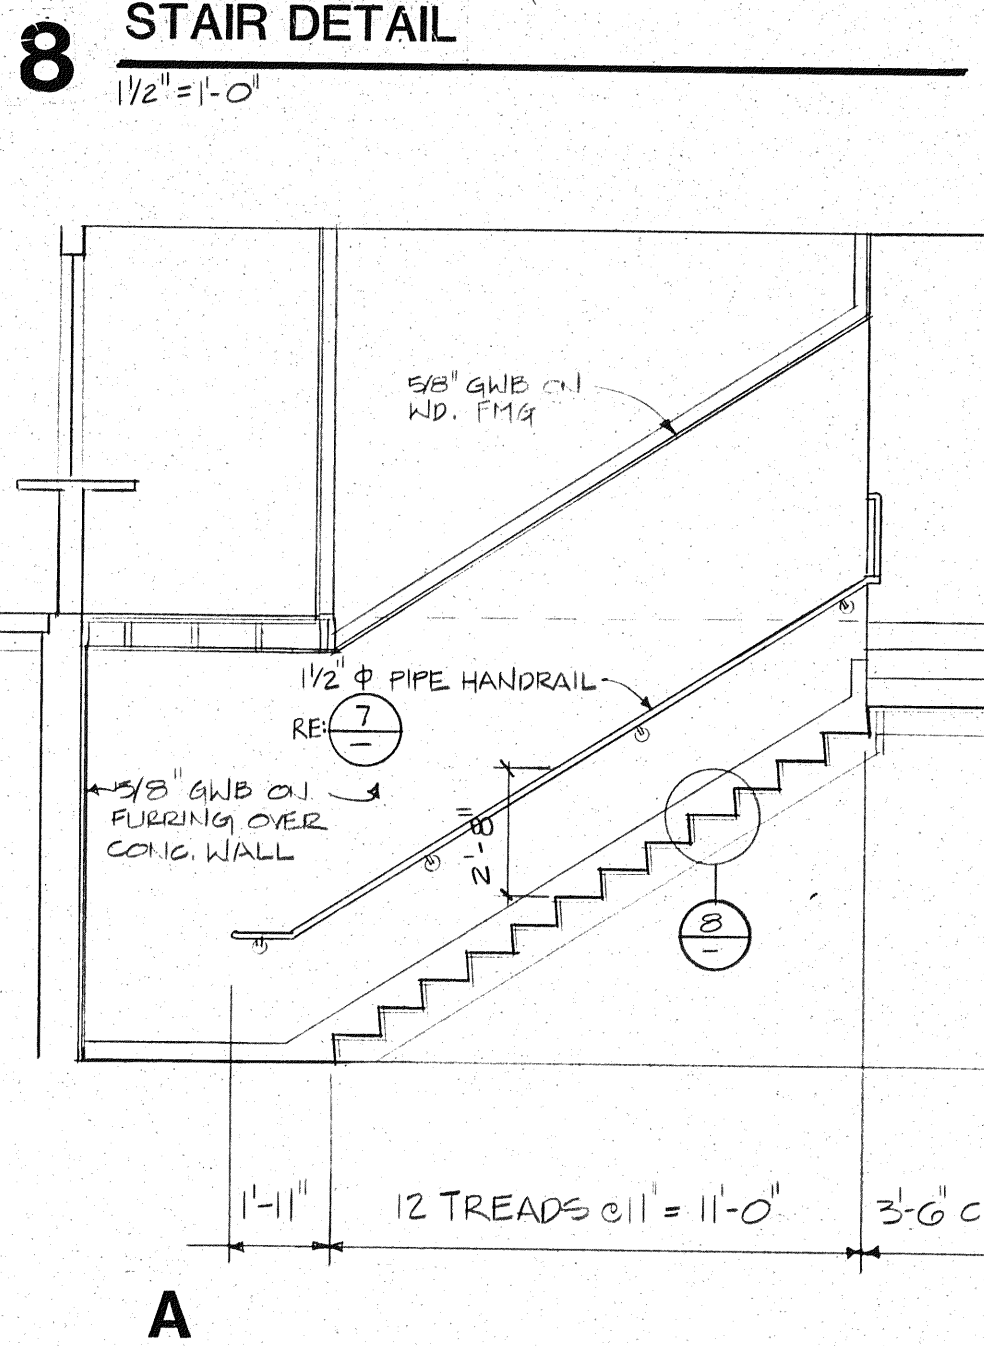
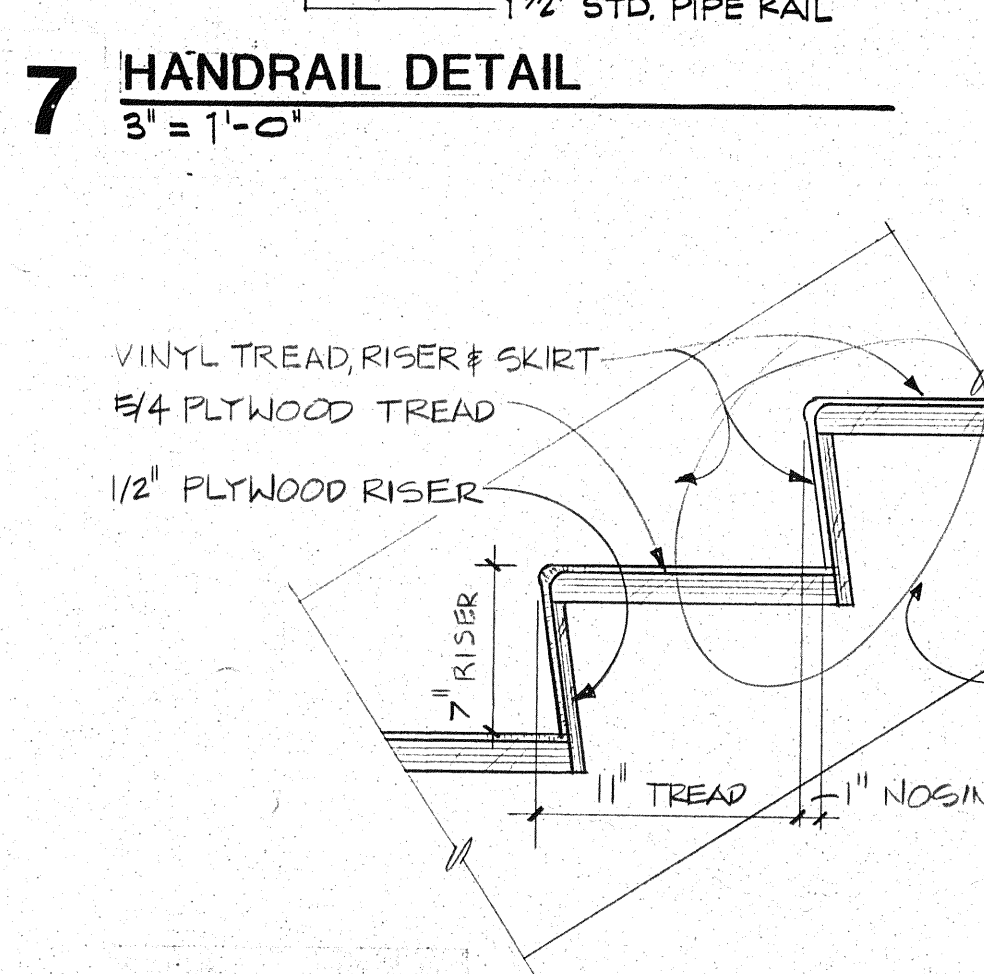
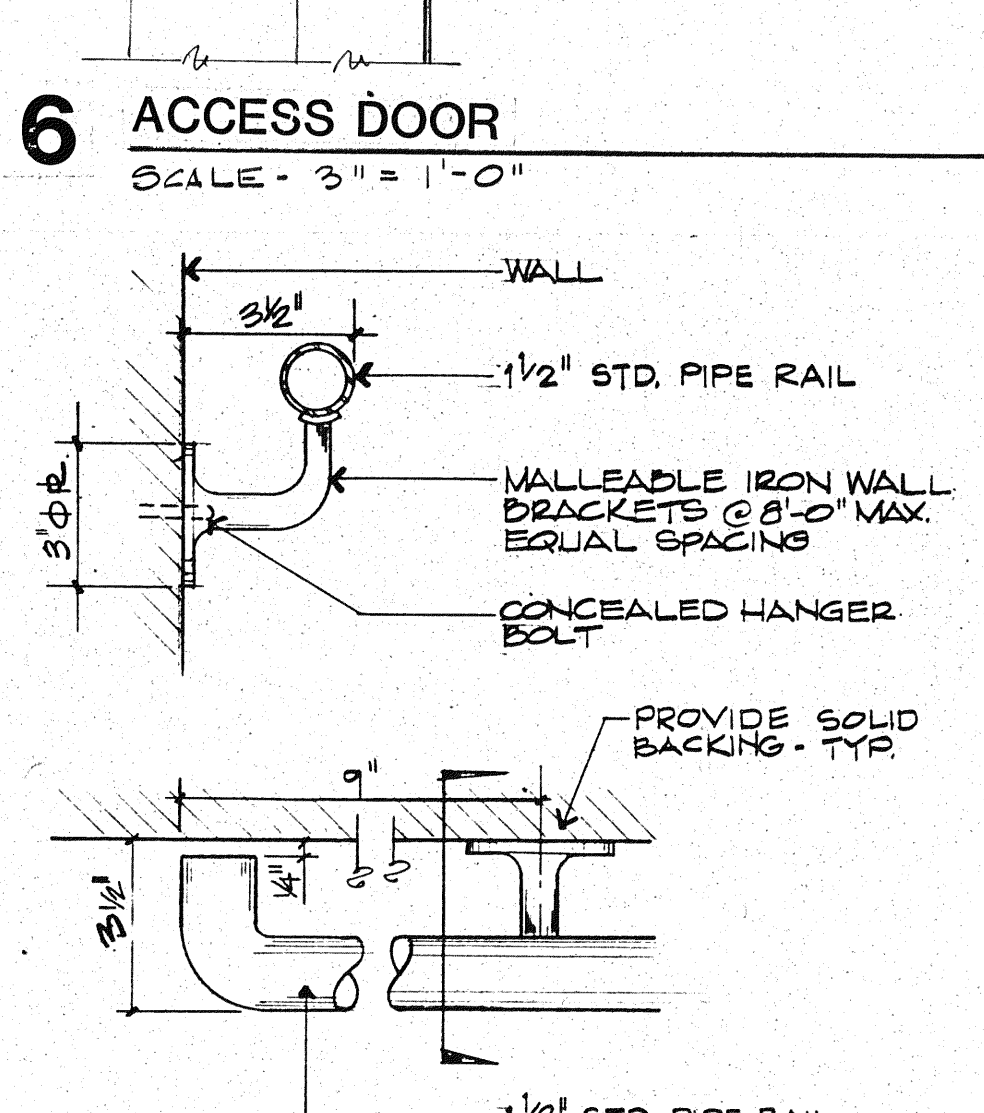


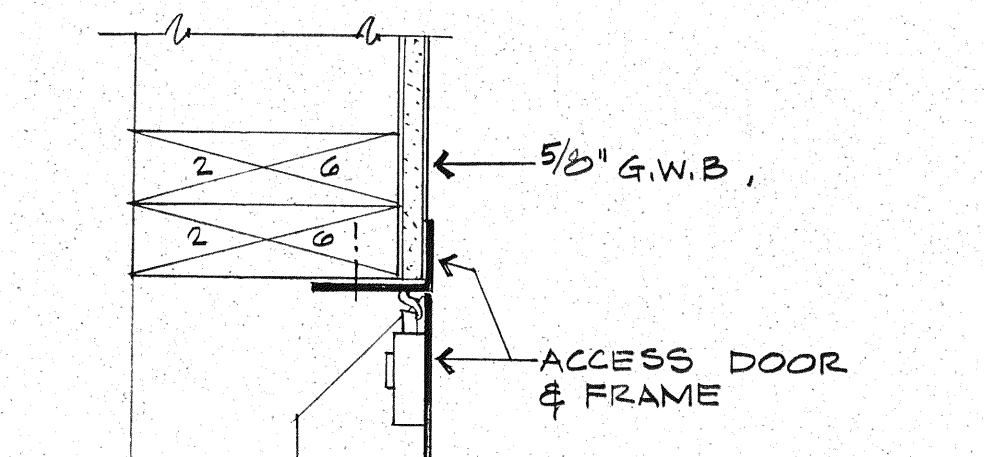

5 FOLDING STAIR
SCALE: 1/2" = 1'-0"

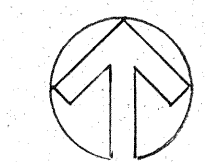


9 SECTIONS THRU STAIR
1/4" = 1'-0"

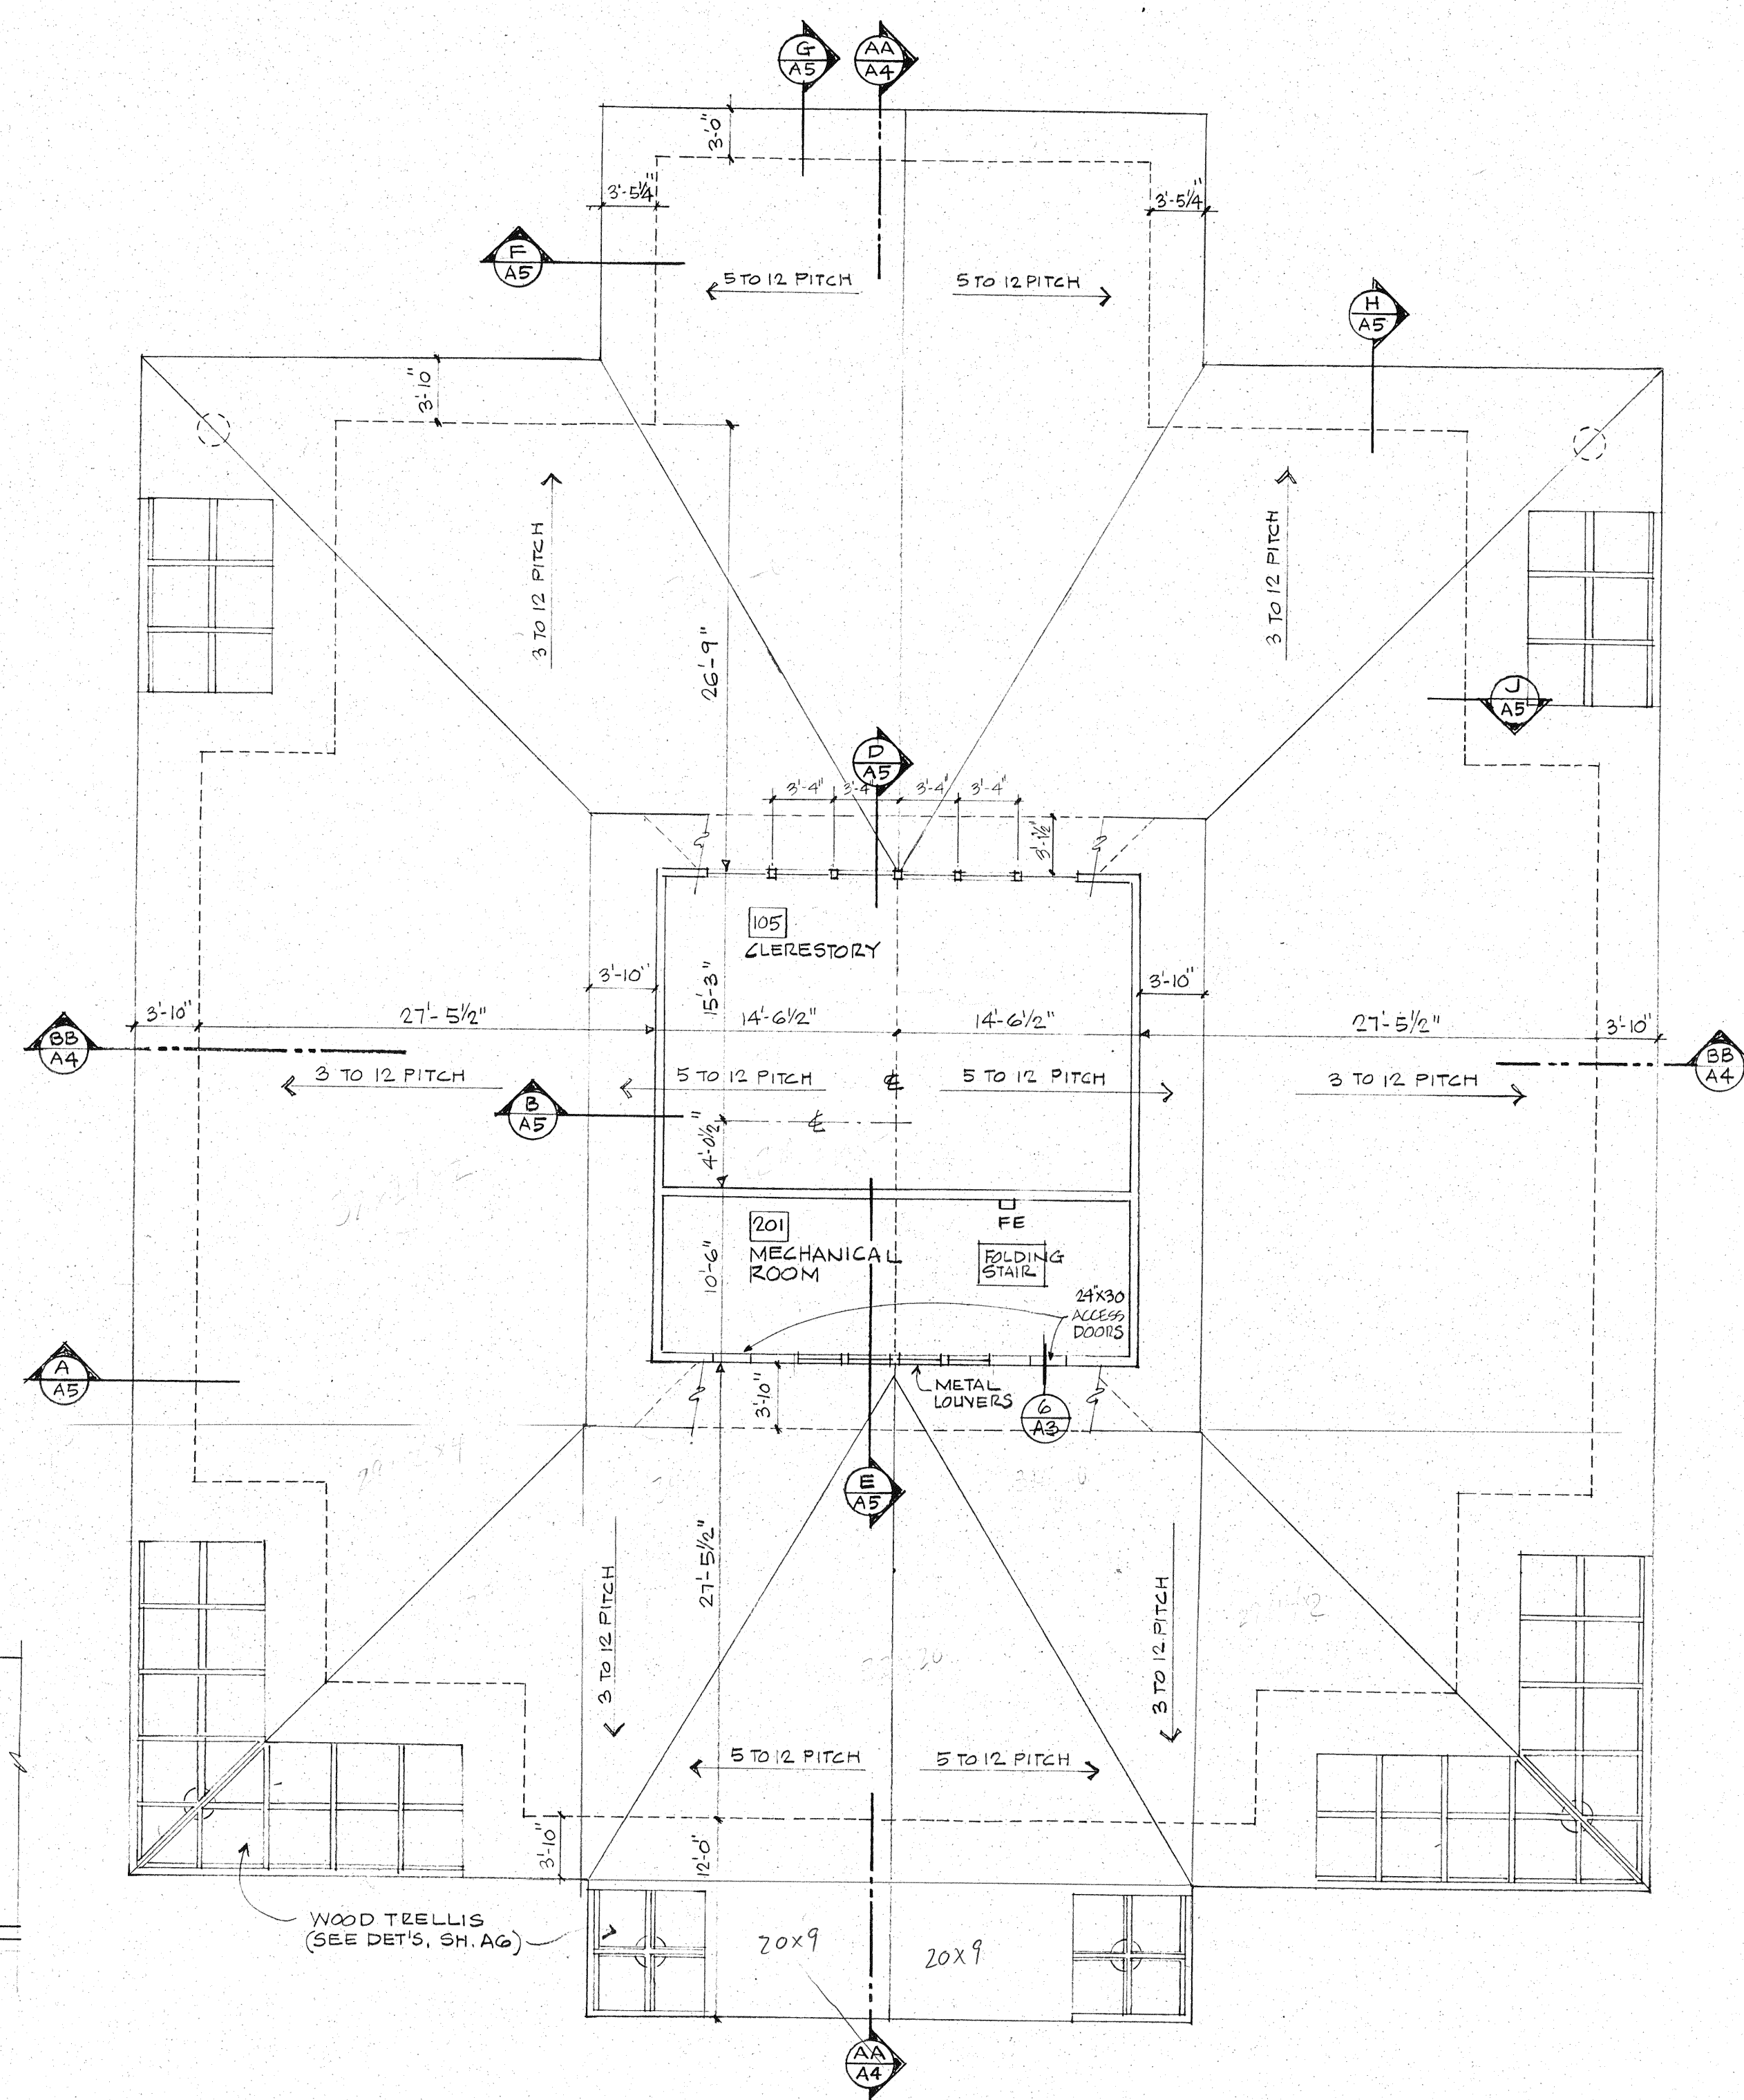

MECHANICAL ROOM & ROOF PLAN
SCALE: 1/8" = 1'-0"

CITY OF
COLLEGE PLACE
MUNICIPAL
BUILDING

COLLEGE PLACE,
WASHINGTON

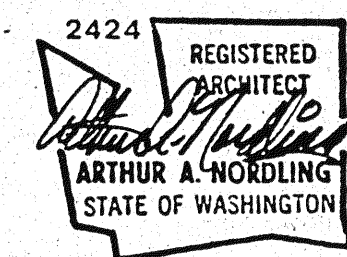

Architects & Engineers
INTÉGRUS
ARCHITECTURE

244 West Main Avenue
Spokane, Washington 99201
509/838-8681
FAX 509/838-2194

Mechanical/Electrical Engineers
MW Consulting Engineers
Great Northwest Bldg., Suite 200
222 North Wall Street
Spokane, Washington 99201-0877
509/838-9020
FAX 509/838-1123

Job Number 9119.50
Drawn By W-J SE
Checked By
Date 9-10-91
Revisions

Sheet Contents
MECHANICAL ROOM & ROOF
PLAN & DETAILS

A3