


CITY OF COLLEGE PLACE MUNICIPAL BUILDING

COLLEGE PLACE,
WASHINGTON

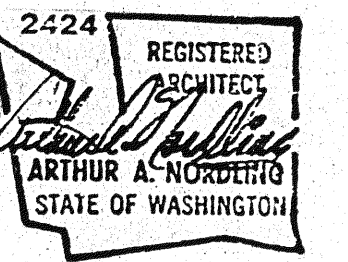


Architects & Engineers

INTÉGRUS
ARCHITECTURE


244 West Main Avenue
Spokane, Washington 99201
509/838-8681
FAX 509/838-2194

Mechanical/Electrical Engineers


MW Consulting Engineers
Great Northwest Bldg., Suite 200
222 North Wall Street
Spokane, Washington 99201-0877
509/838-9020
FAX 509/838-1123

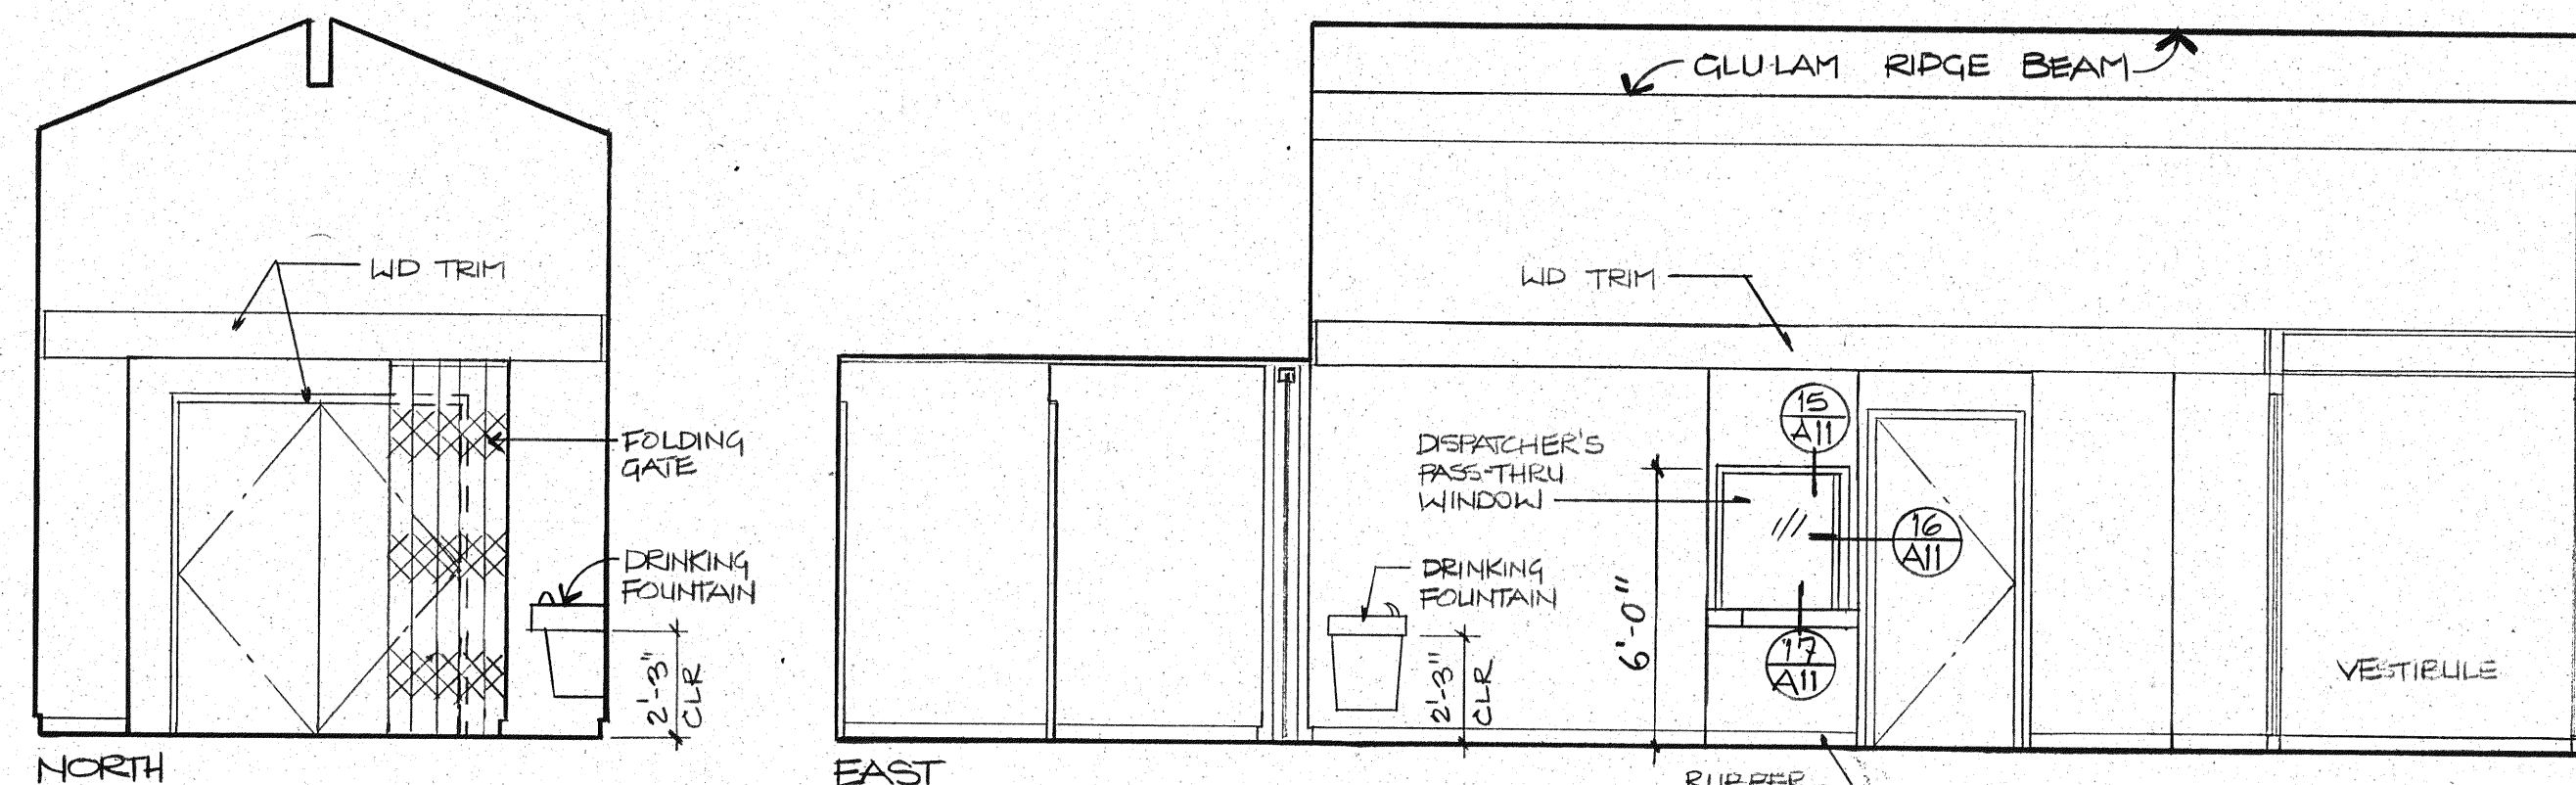


101/102 VESTIBULE/PUBLIC LOBBY
SCALE - 1/4" = 1'-0"

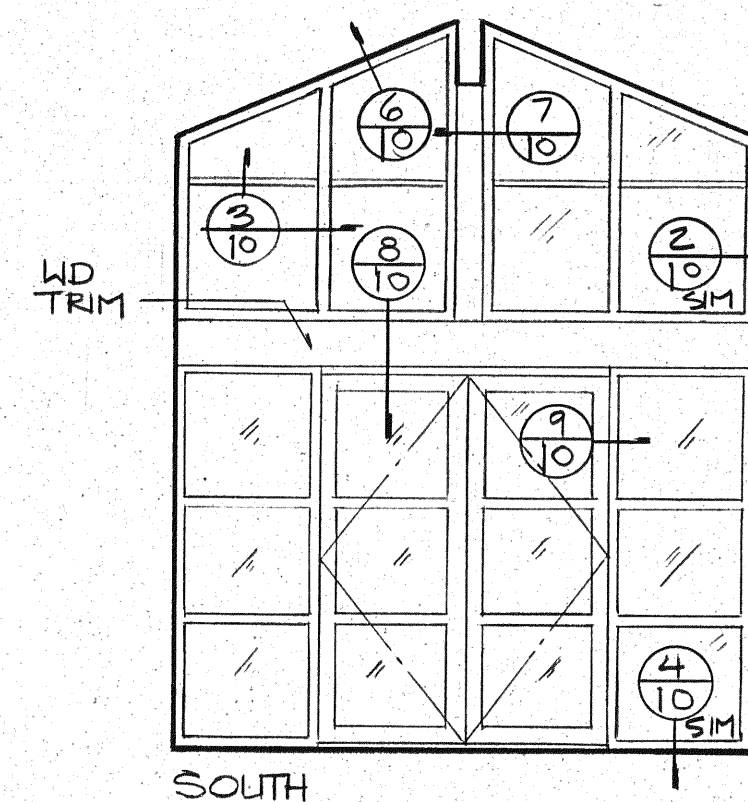


SOUTH

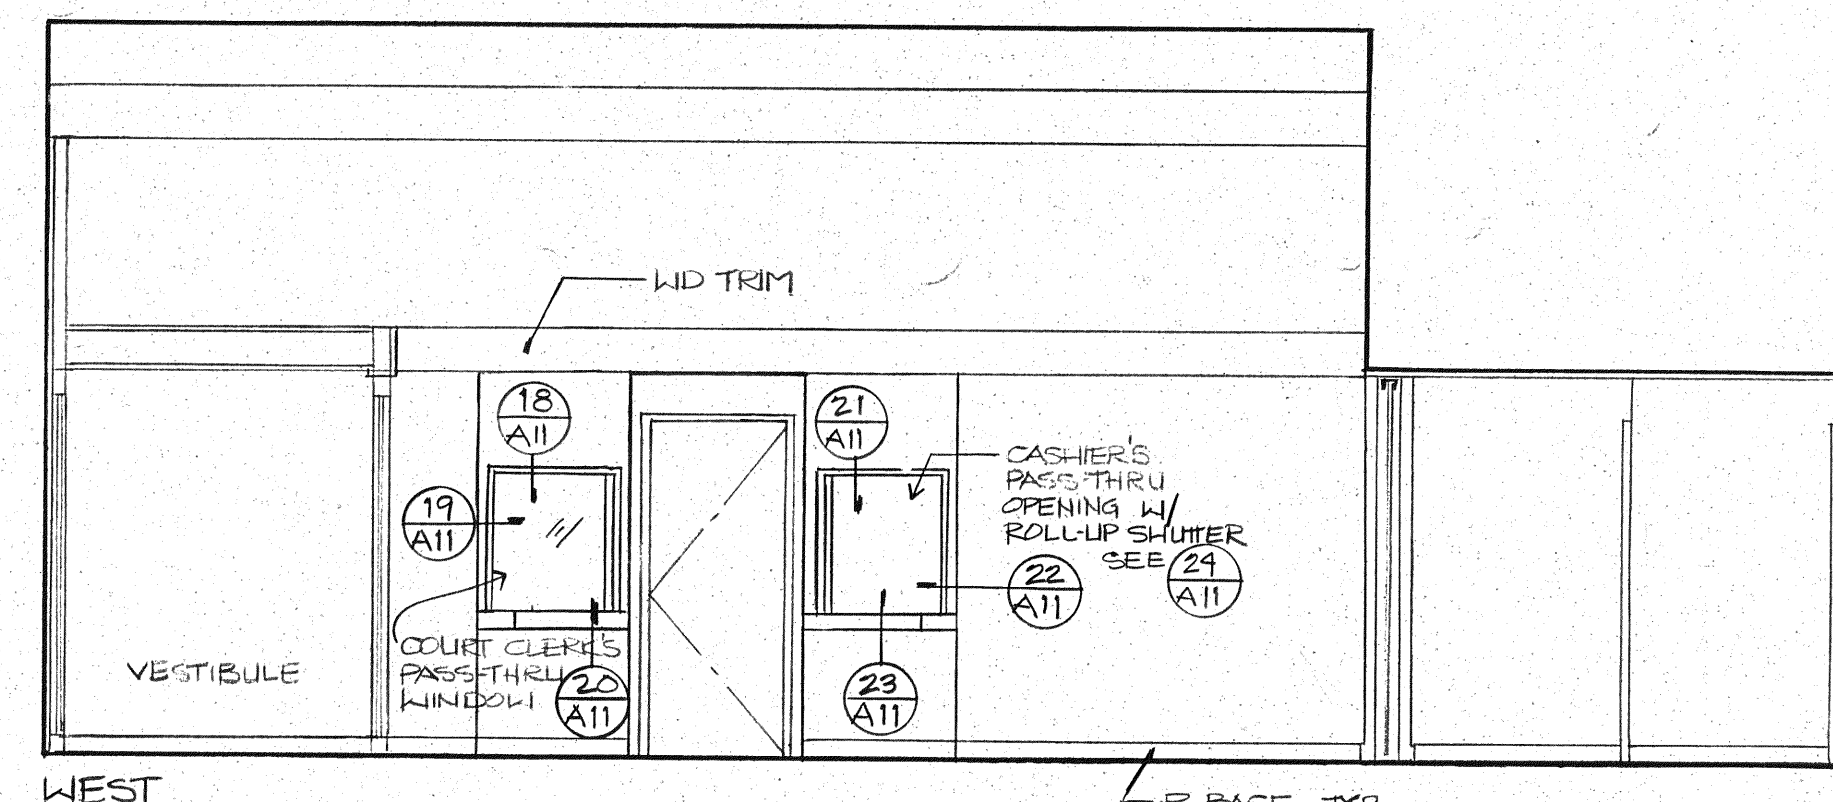


WEST

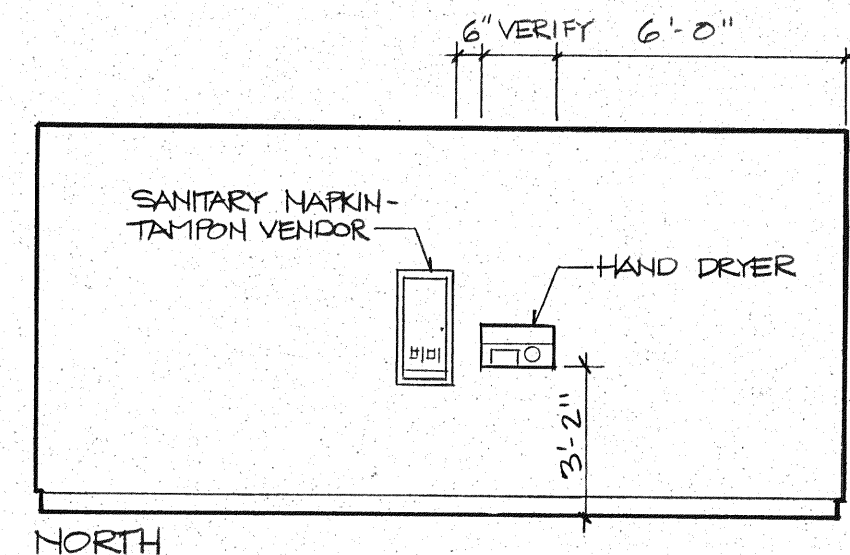


NORTH

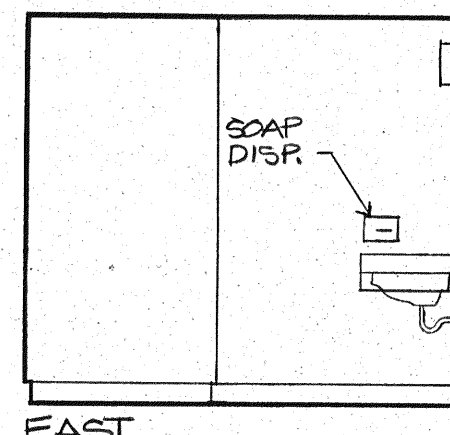


EAST

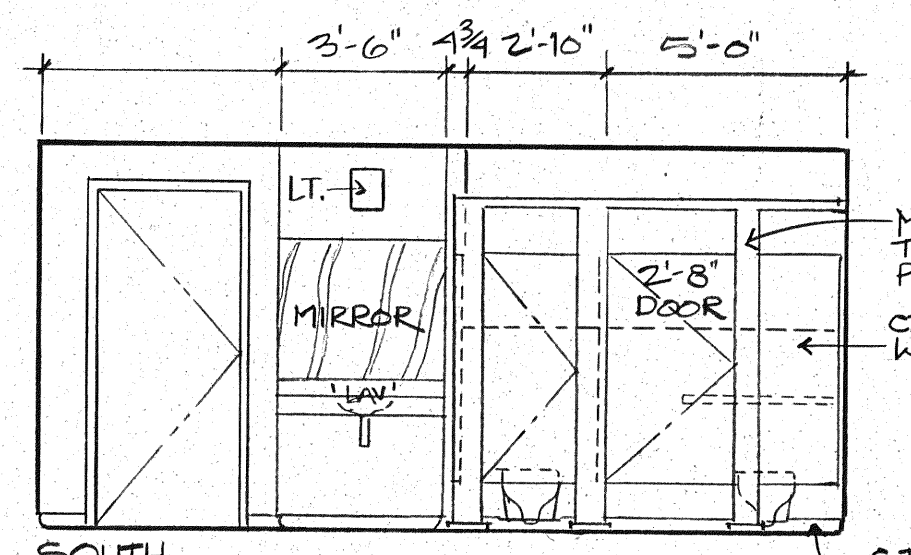


SOUTH

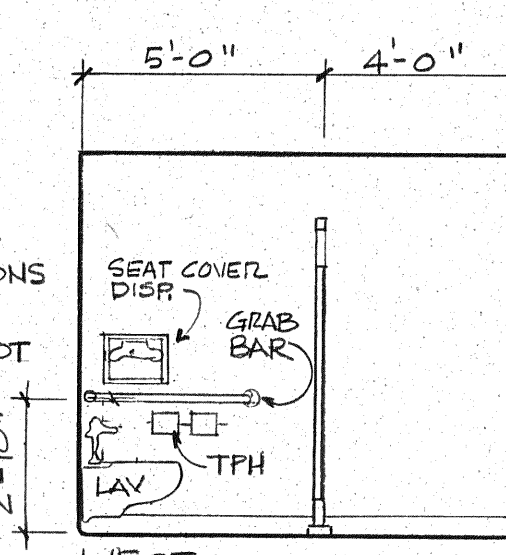


WEST

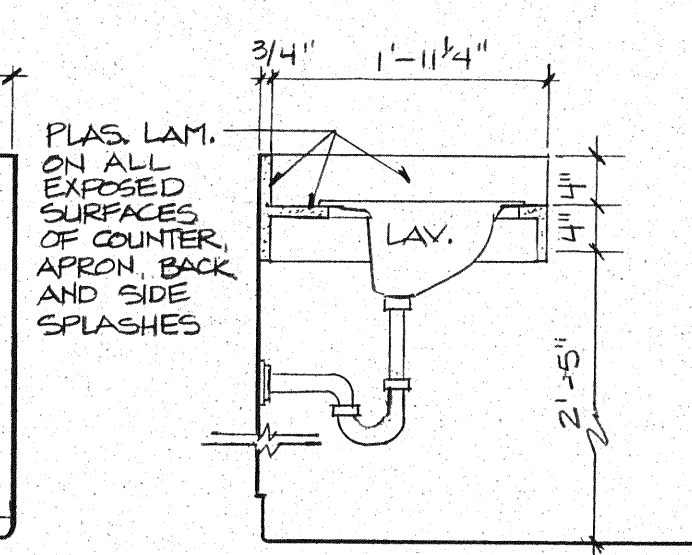

LAV. DETAIL
3/4" = 1'-0"

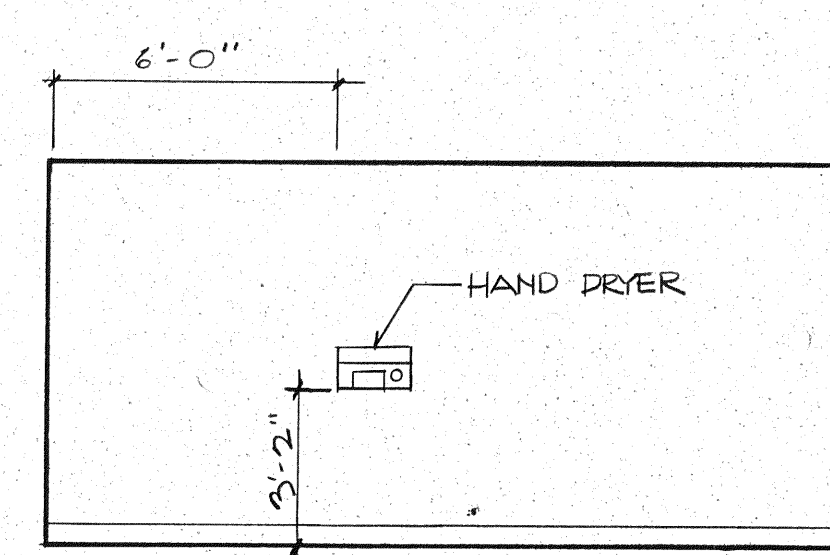


NORTH

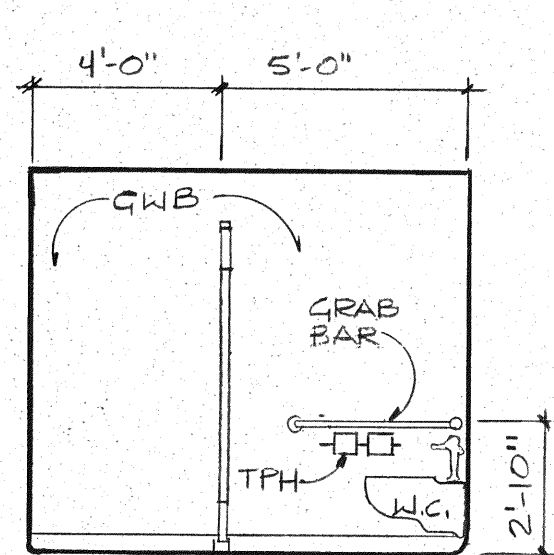


EAST

104 MEN'S PUBLIC TOILET ROOM

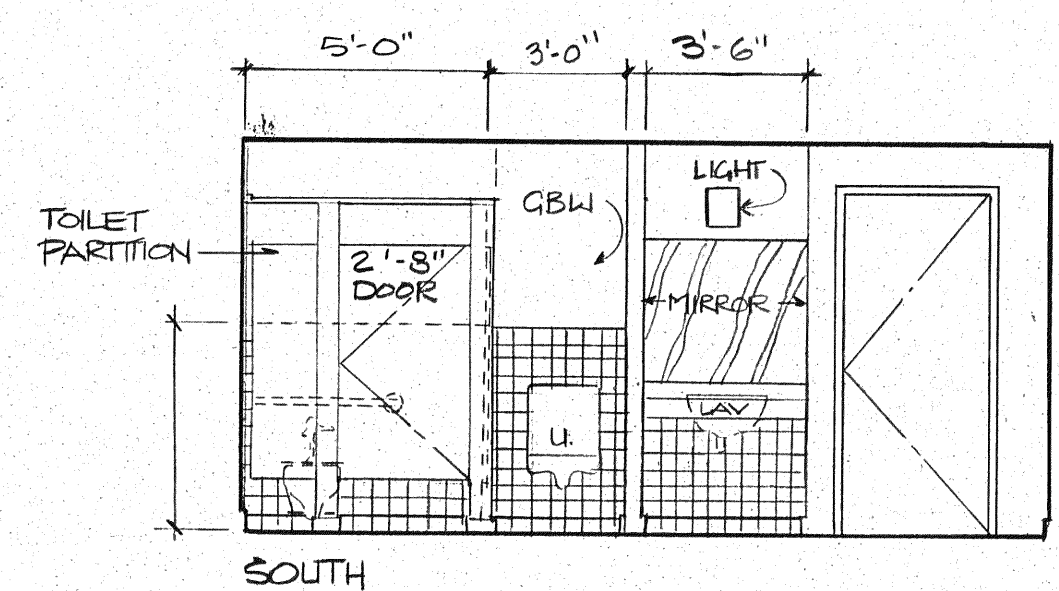


SOUTH

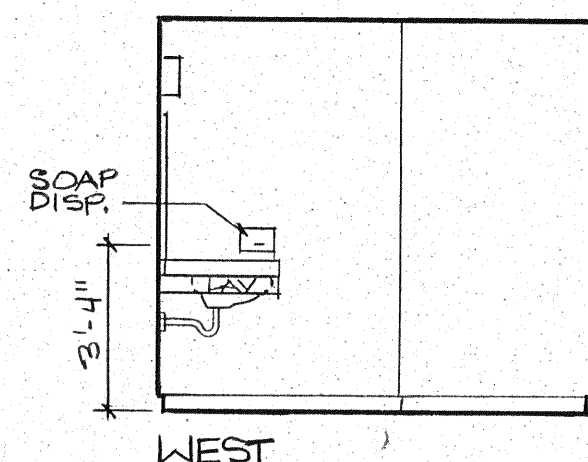


WEST

104 MEN'S PUBLIC TOILET ROOM

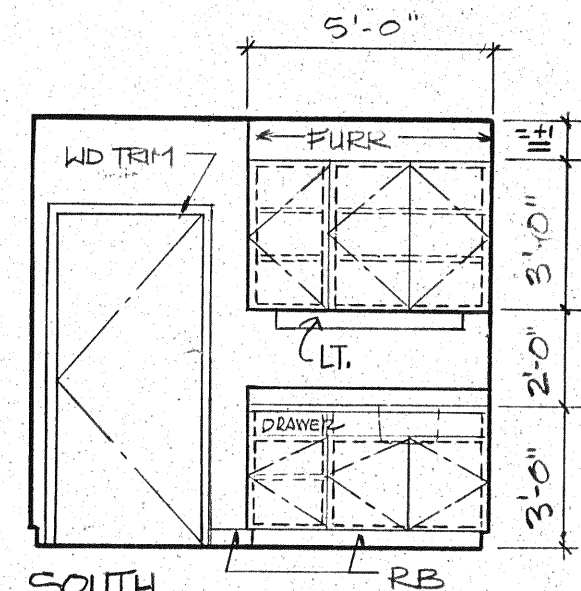


SOUTH

116 BREAK ROOM

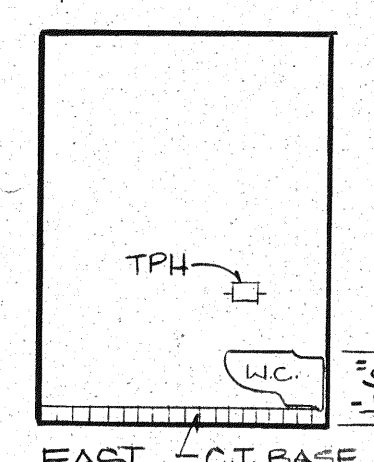


EAST


119 TOILET ROOM-TYP.

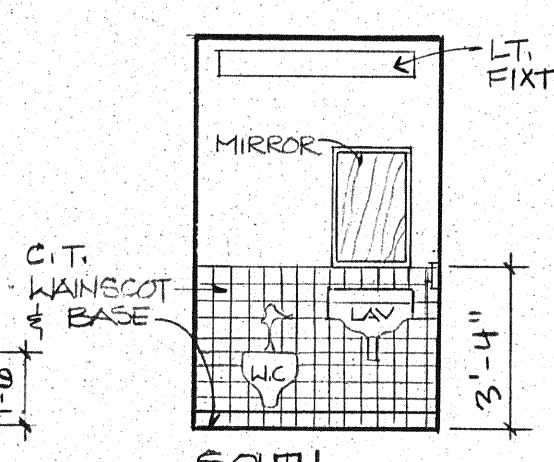


SOUTH

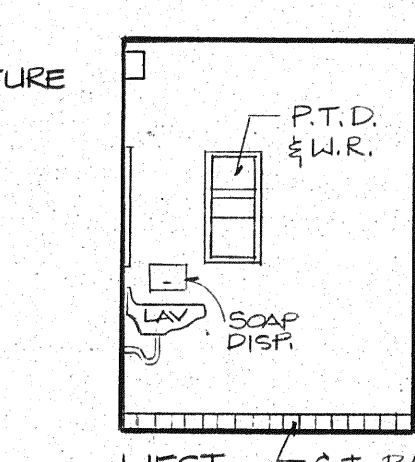


WEST

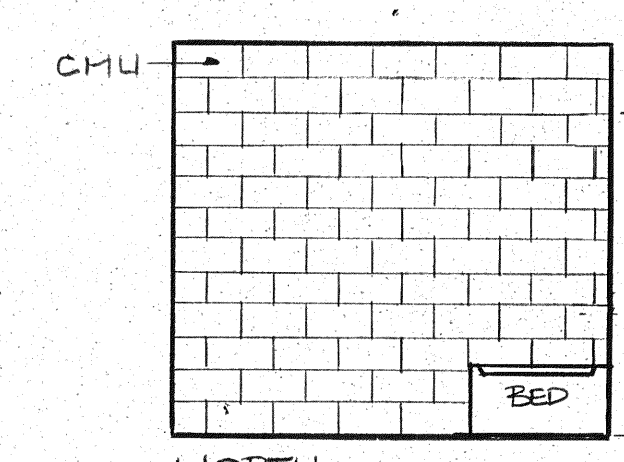

NORTH

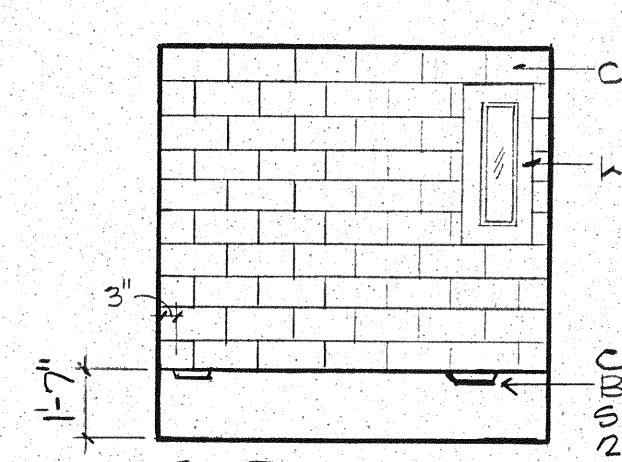


EAST

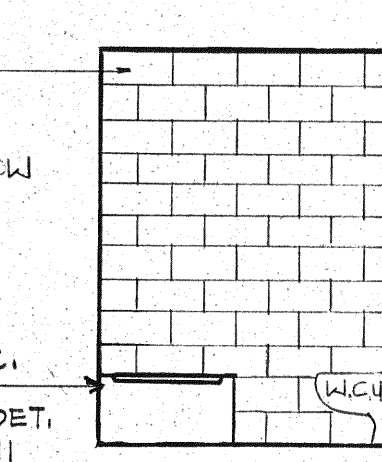


SOUTH

124 HOLDING CELL

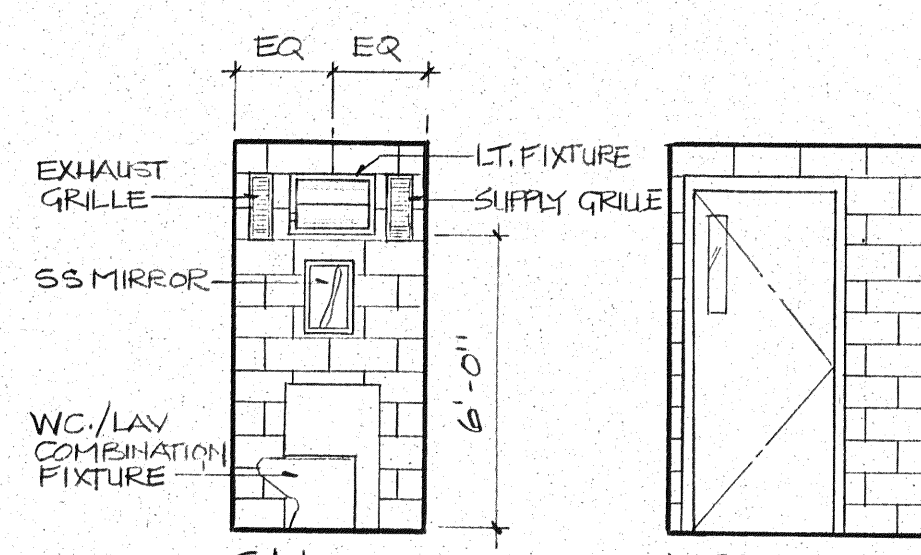


SOUTH

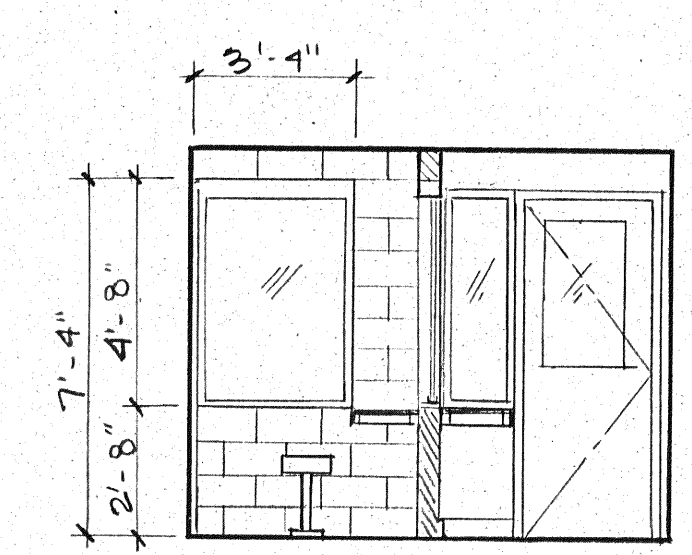


EAST

127/129 INMATE/VISITOR

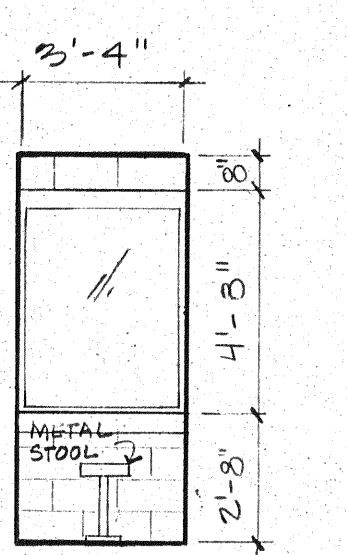


SOUTH

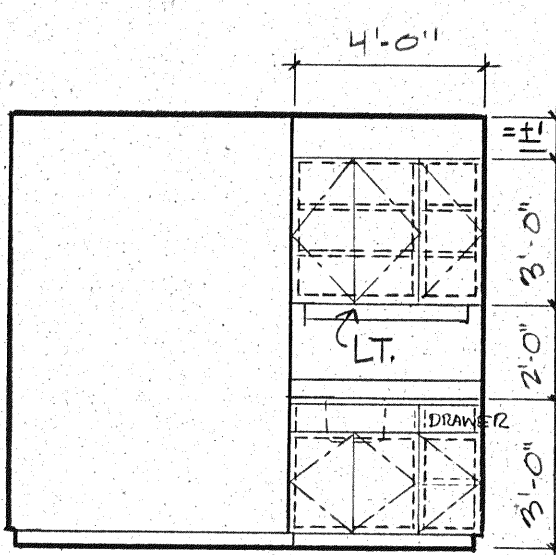


WEST

135 BREAK ROOM

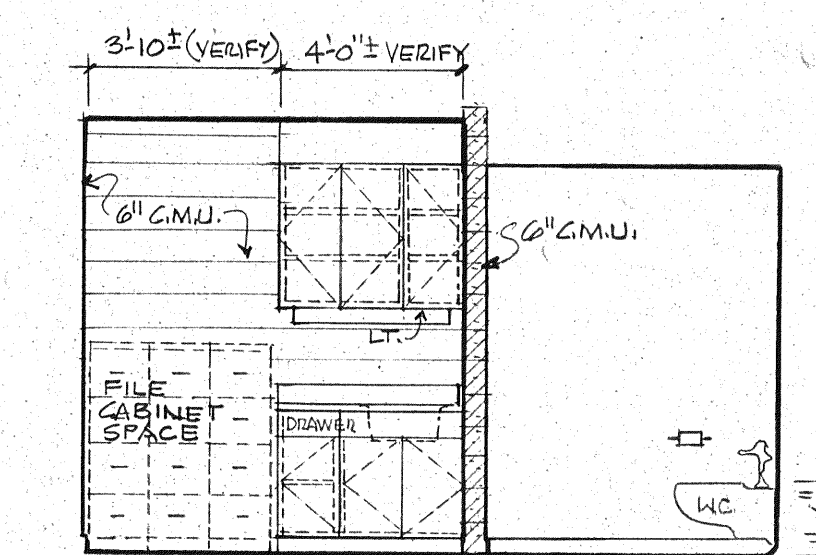


NORTH


141/142 DISPATCH/TOILET

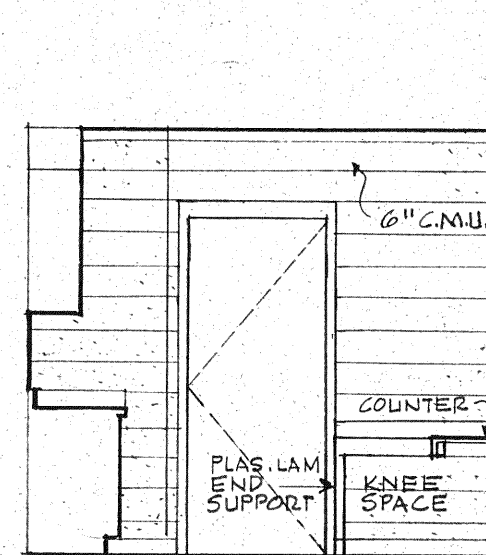


EAST

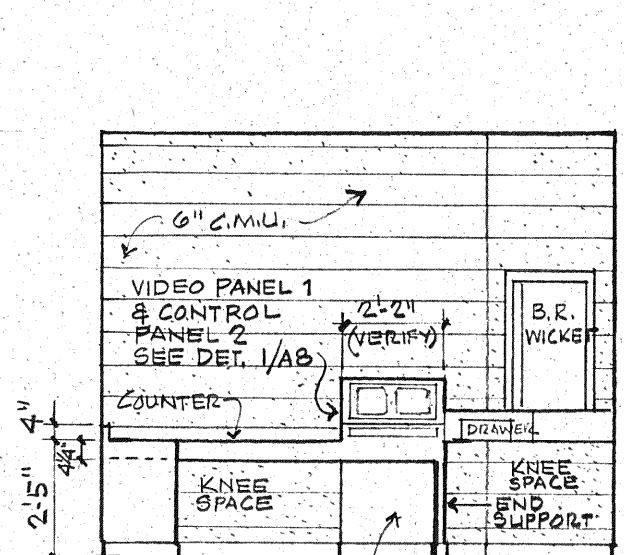


SOUTH

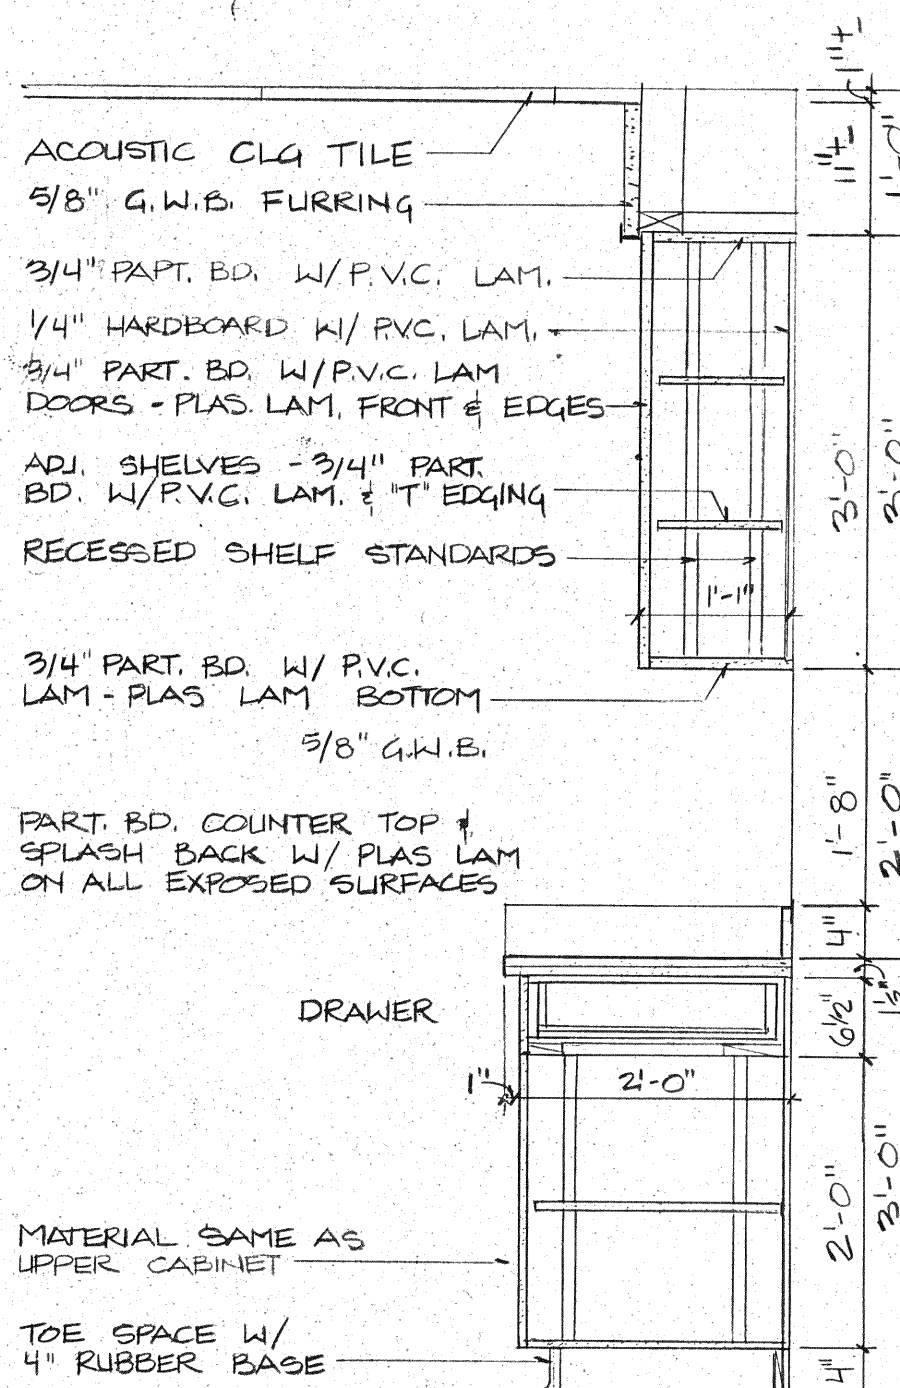


3 COUNTER DETAIL-TYP.
SCALE: 3/4" = 1'-0"

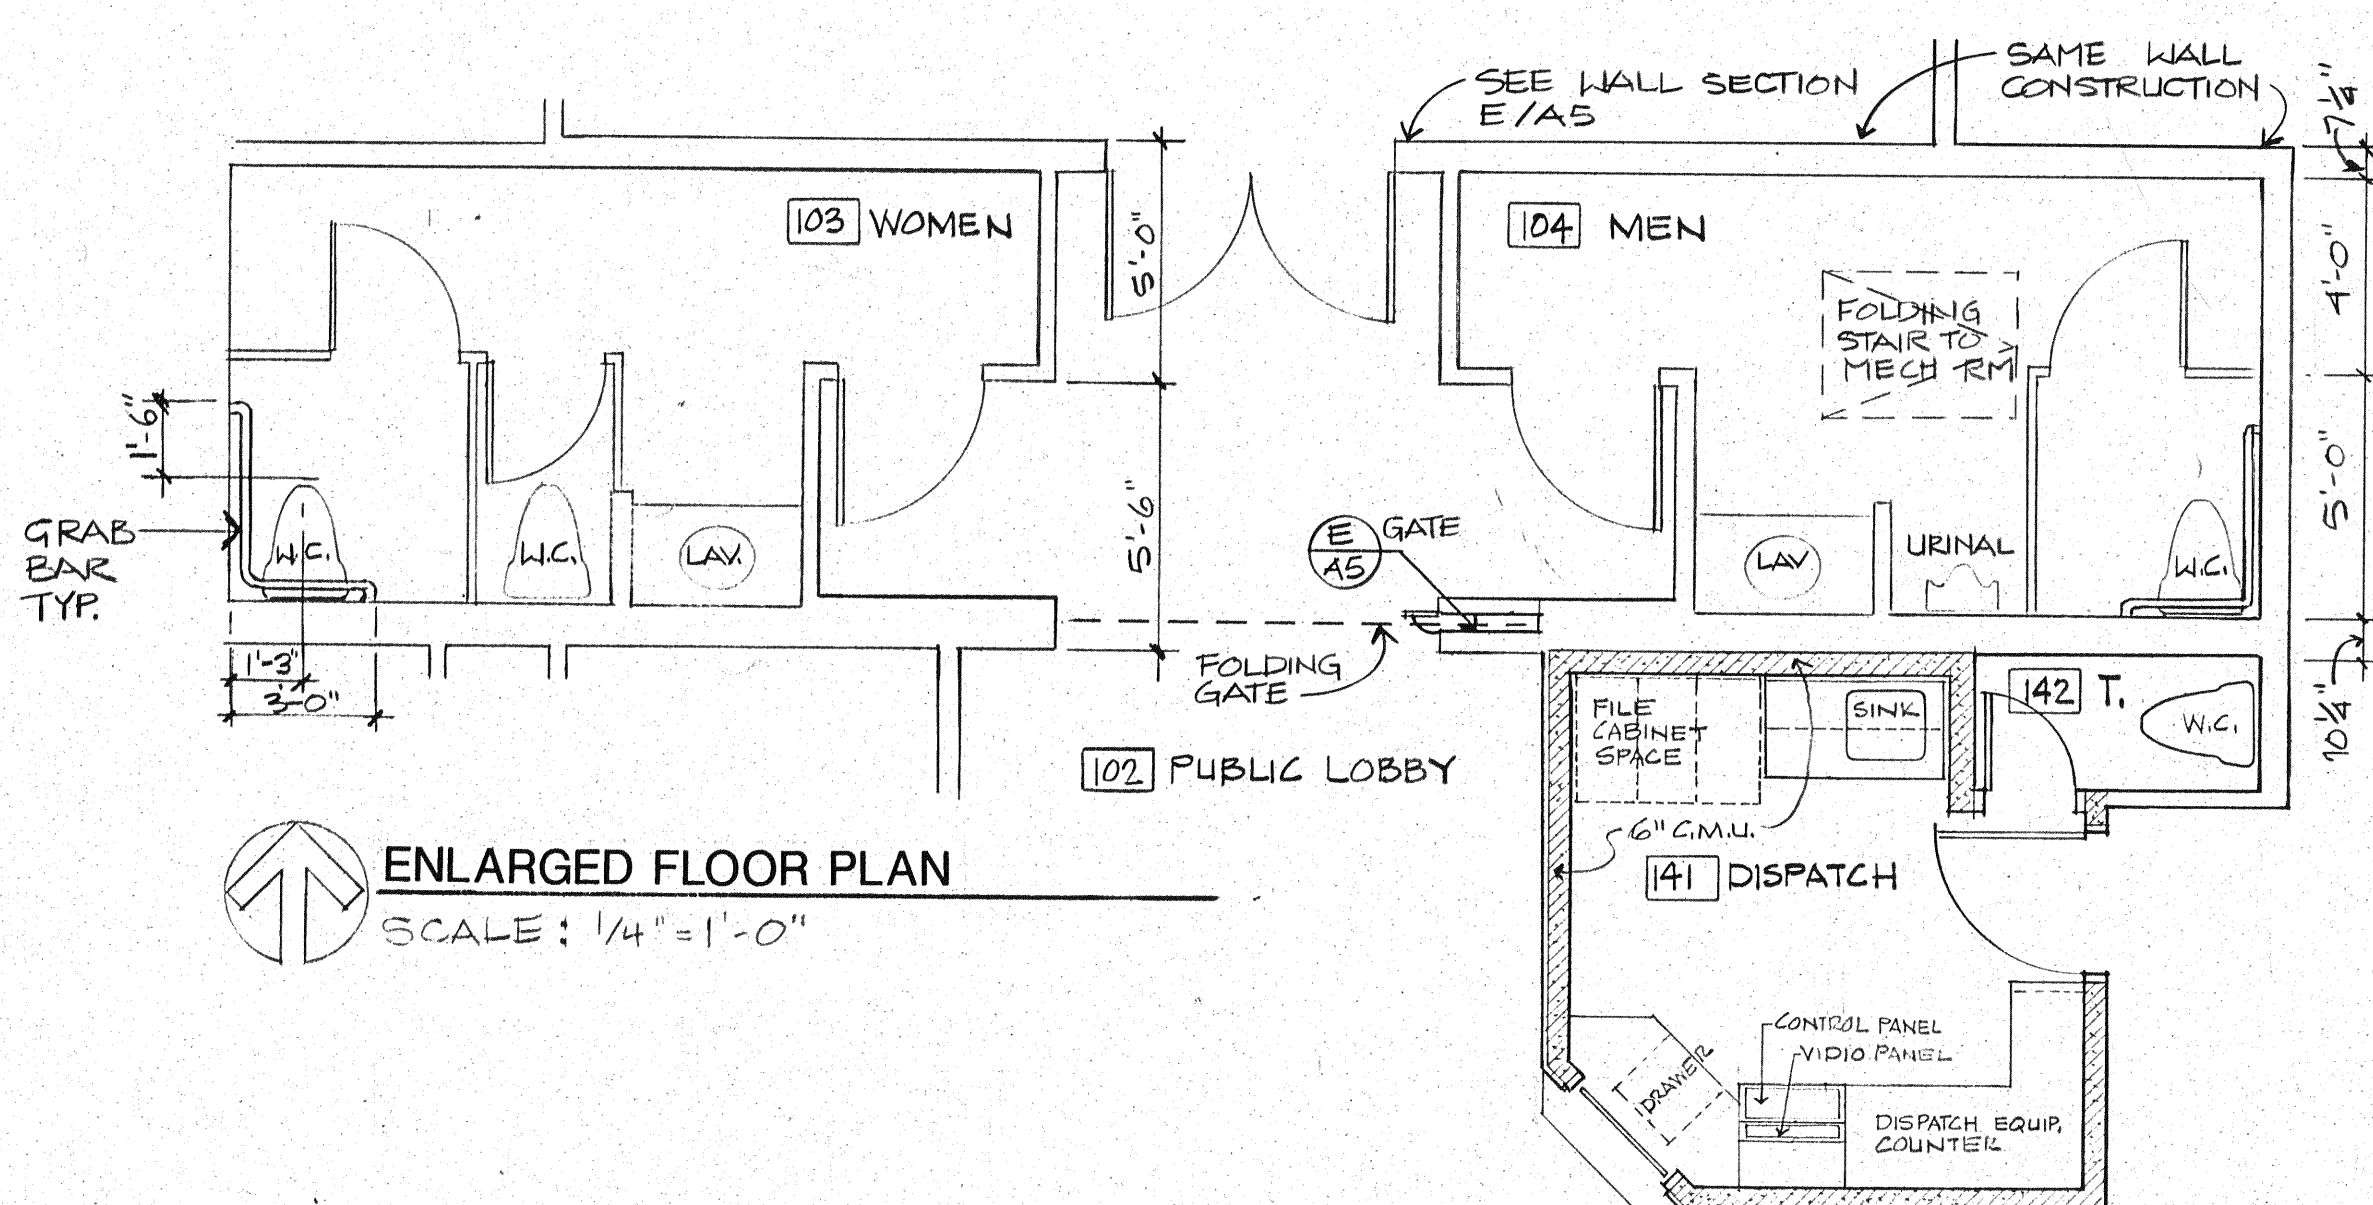


ENLARGED FLOOR PLAN
SCALE: 1/4" = 1'-0"

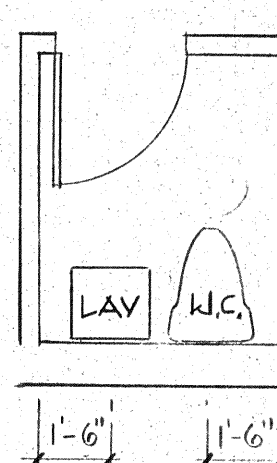

119 TOILET
1/4" = 1'-0"

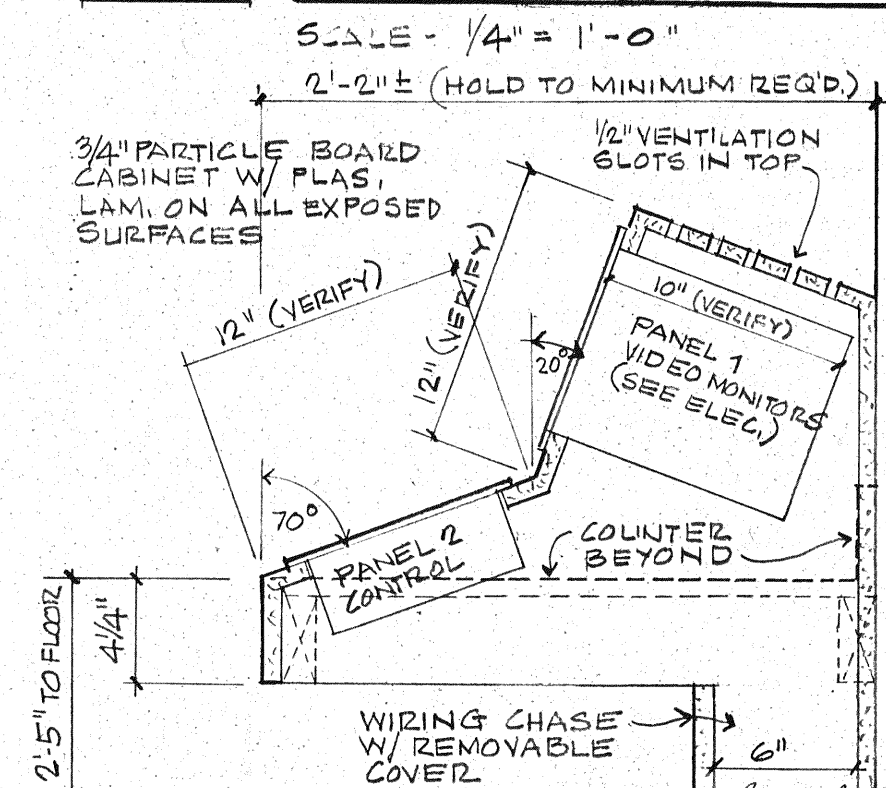

1 CONTROL PANEL CABINET
SCALE: 1/2" = 1'-0"

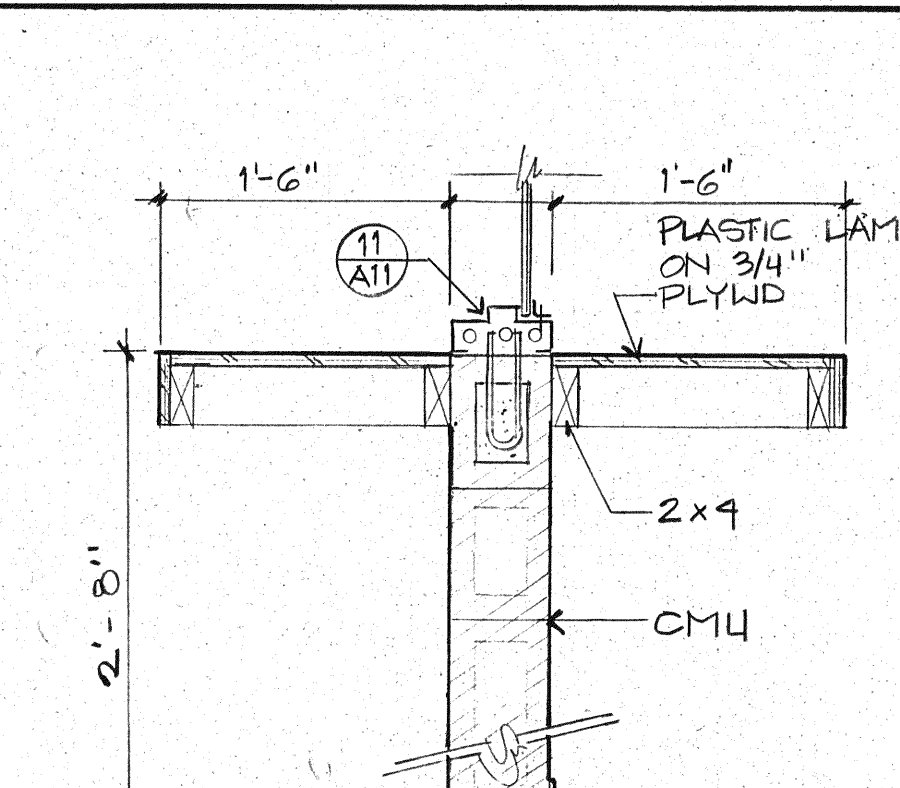

2 INMATE/VISITOR COUNTER
SCALE: 1" = 1'-0"

Job Number 9119.50
Drawn By E.P.
Checked By A.V.
Date 9-10-91
Revisions

Sheet Contents
INTERIOR ELEVATIONS

A8