


COLLEGE PLACE,
WASHINGTON

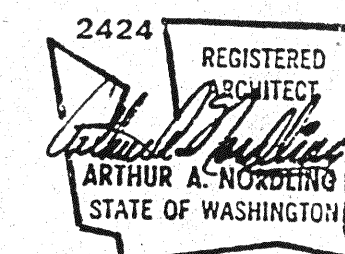

Architects & Engineers

244 West Main Avenue
Spokane, Washington 99201
509/838-8681
FAX 509/838-2194

Mechanical/Electrical Engineers

MW Consulting Engineers
Great Northwest Bldg., Suite 200
222 North Wall Street
Spokane, Washington 99201-0877
509/838-9020
FAX 509/838-1123

Job Number	9119.50
------------	---------

Drawn By E.P.

Checked By A

Date 9/10/91

Revisions _____

Sheet Contents


SITE PLAN

DETAILS


© 2004 Blackwell Publishing Ltd, *Journal of Internal Medicine* 255: 105–112

1. LOCATION OF EXIST. FOUND. AS SHOWN ON THIS PLAN SHALL BE VERIFIED. FOUNDATION LOCATED UNDER NEW BUILDING SHALL BE REMOVED 4'-0" MIN. BELOW NEW BLDG. FLOOR LINE & REPLACE W/ STRUCTURAL FILL AS SPECIFIED.


2. OTHER FOUNDATIONS TO BE REMOVED 2'-0" MIN. BELOW FINISHED PAVING SURFACES AND MIN. 1'-0" BELOW STORM SEWER LINES.

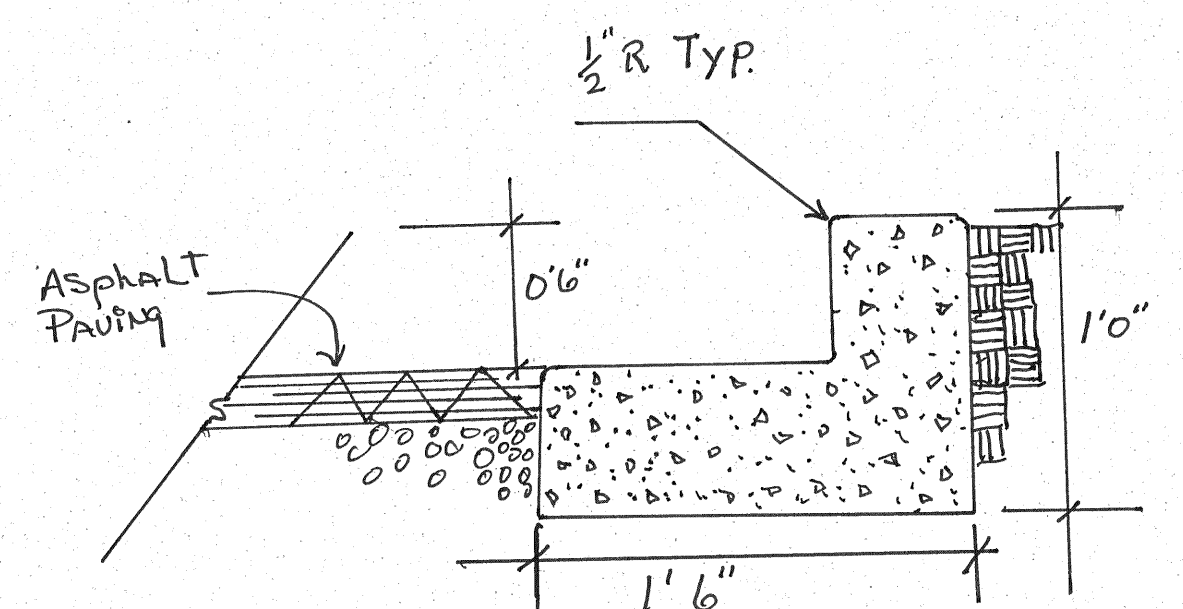


CURB DETAIL

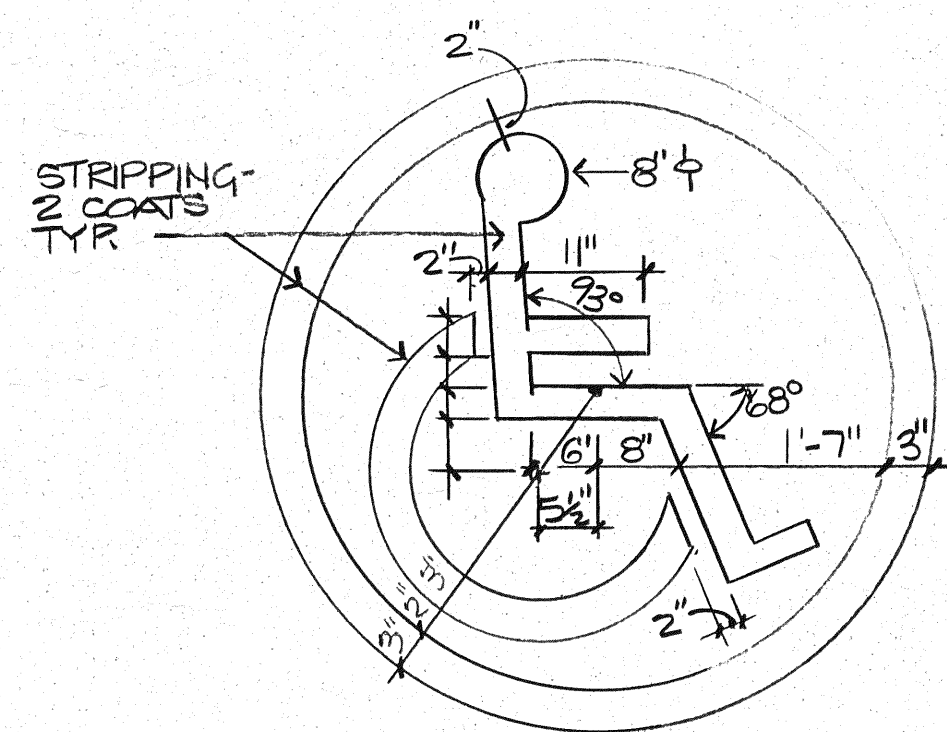


1 DISABLED PERSON SYMBOL
N.T.S.

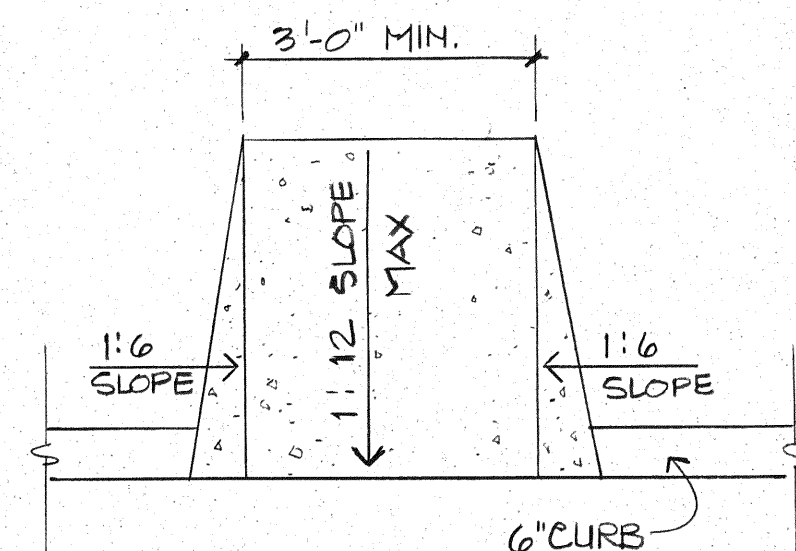



2 HANDICAPPED ACCESS RAMP - TYP.
N.T.S.

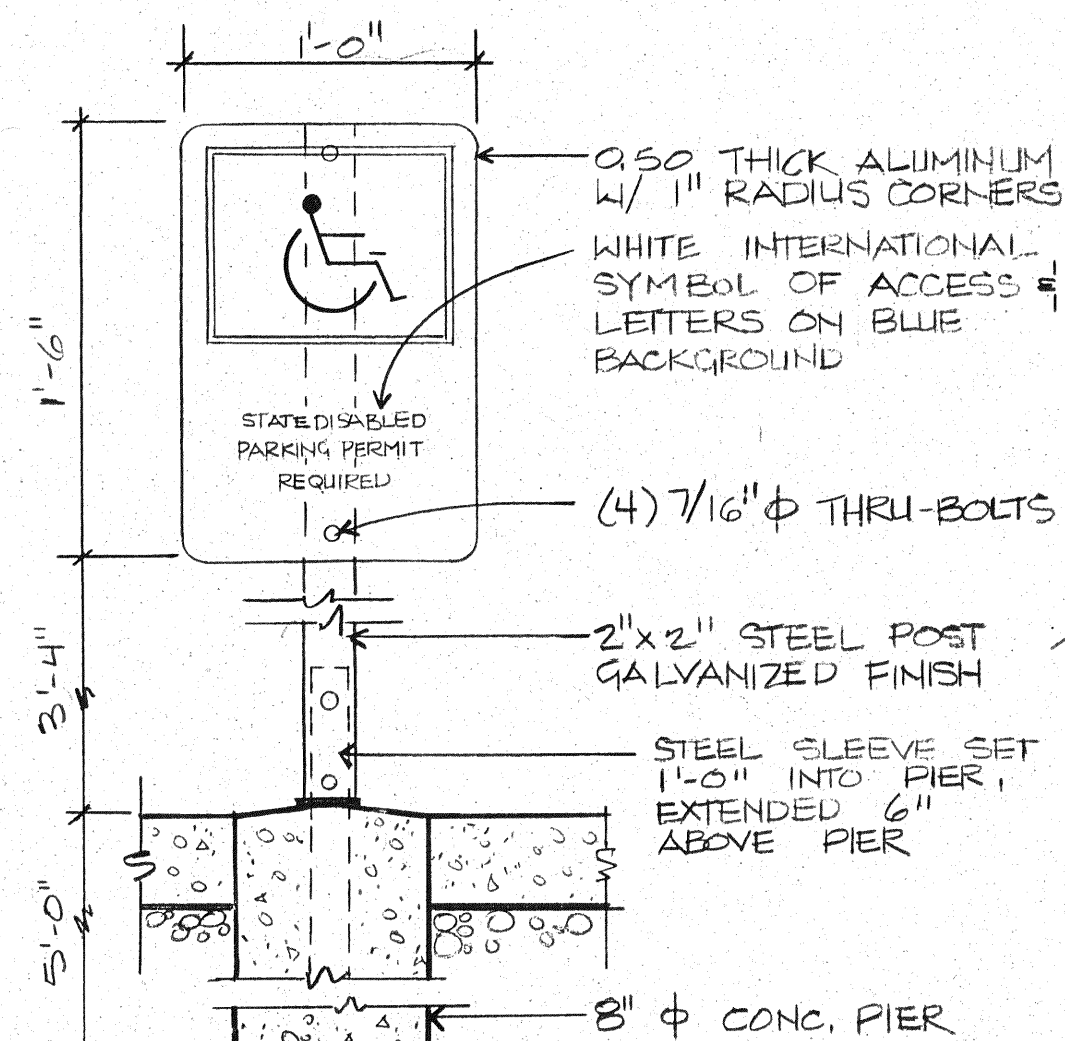

3' DISABLED PARKING SIGN

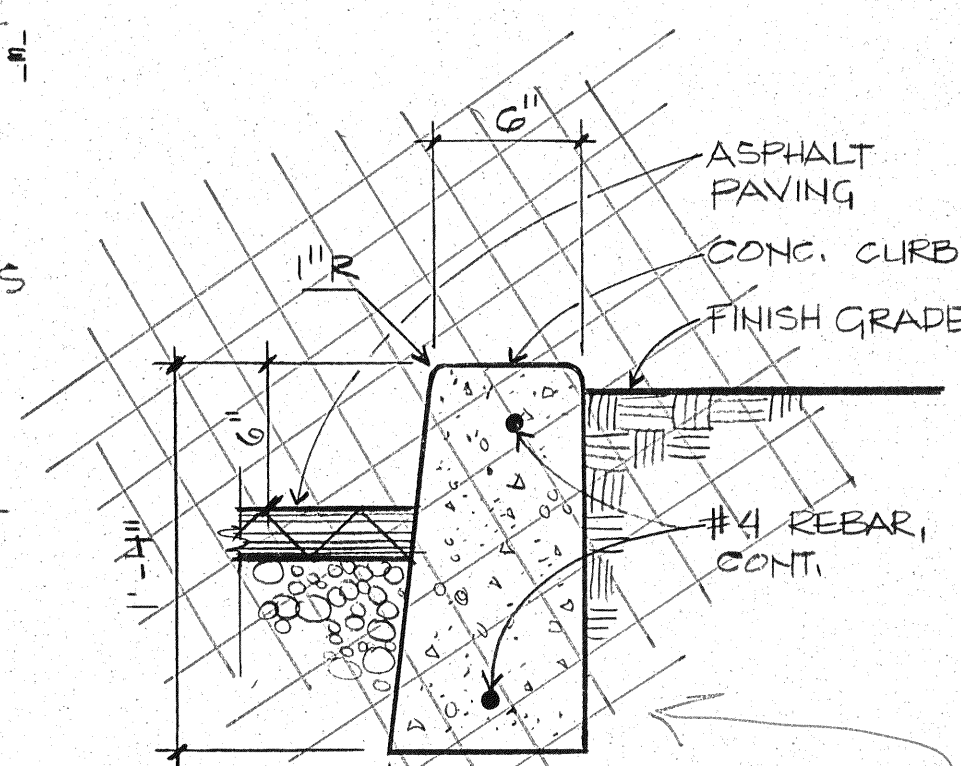

4 CURB DETAIL

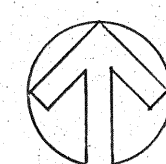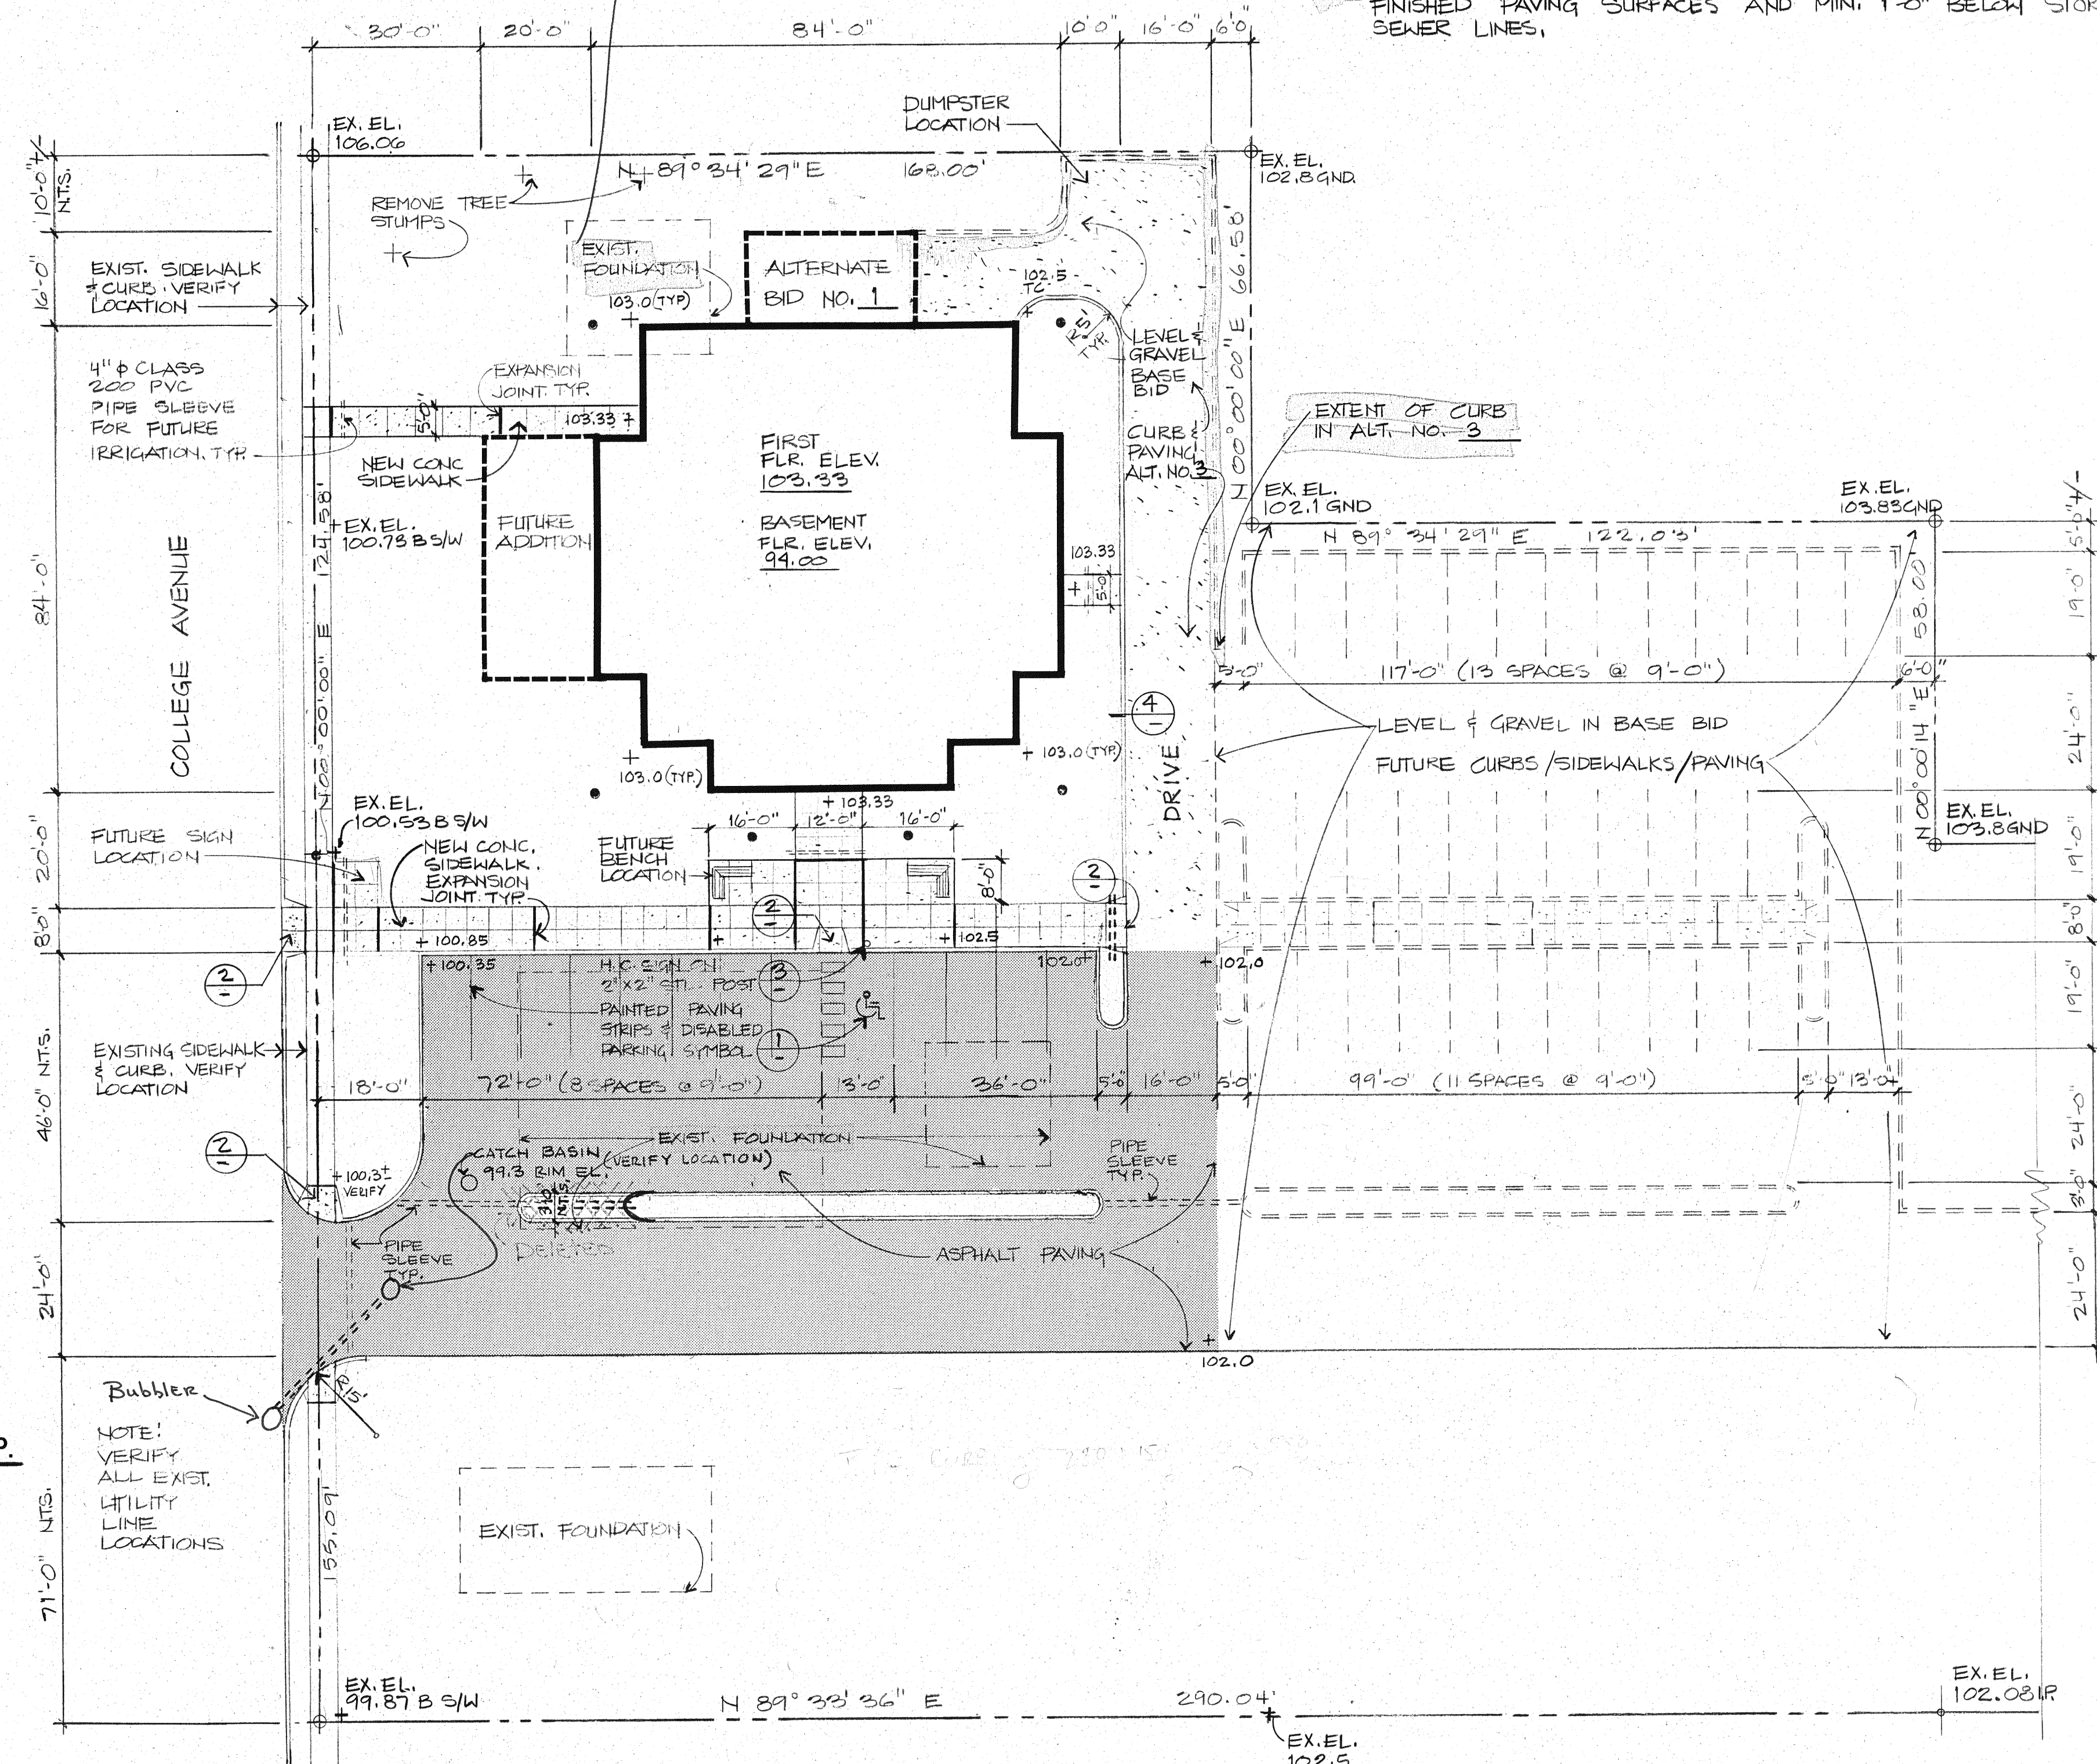

SITE PLAN
SCALE - 1" = 20'-0"