

CITY OF
COLLEGE PLACE
MUNICIPAL
BUILDING

COLLEGE PLACE,
WASHINGTON



Architects & Engineers

INTEGRUS
ARCHITECTURE

244 West Main Avenue
Spokane, Washington 99201
509/838-8681
FAX 509/838-2194

Mechanical/Electrical Engineers

MW Consulting Engineers
Great Northwest Bldg., Suite 200
222 North Wall Street
Spokane, Washington 99201-0877
509/838-9020
FAX 509/838-1123

Job Number 9119.50

Drawn By JHP


Checked By RHW

Date 7-18-91

Revisions

Sheet Contents
MAIN & BASEMENT
FLOOR PLAN -
SYSTEMS


E5

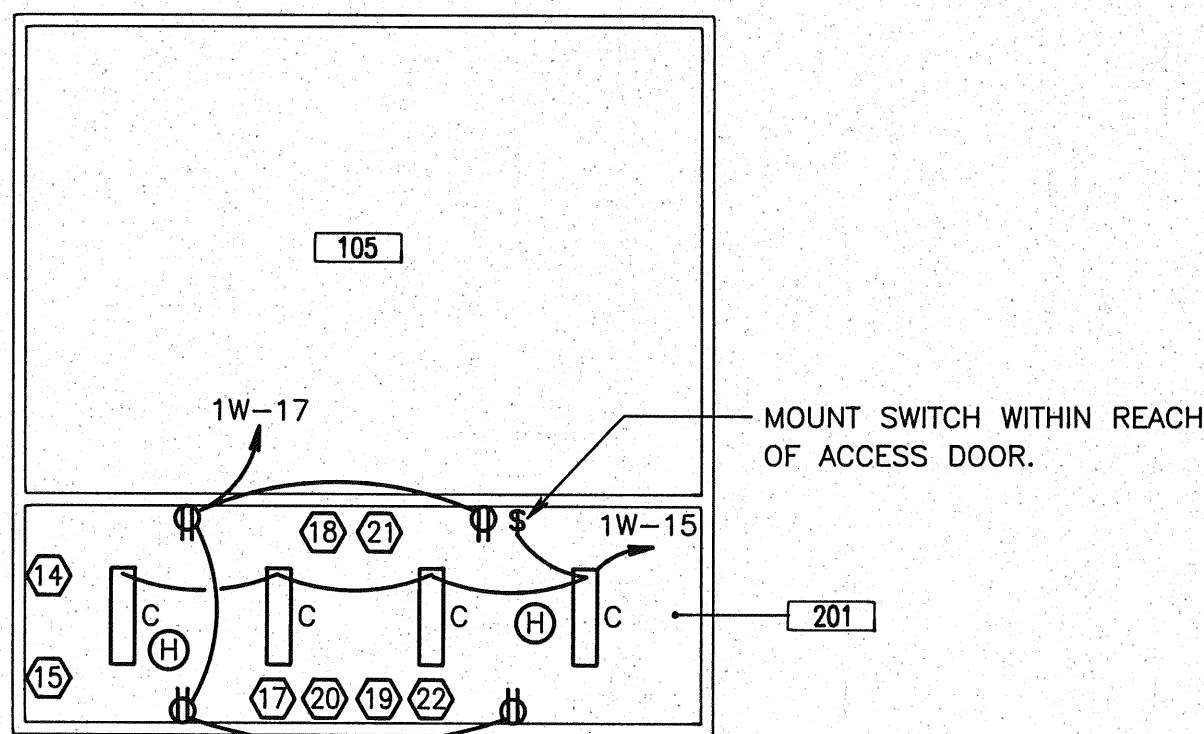

MECHANICAL ROOM FLOOR PLAN


SCALE: 1/8" = 1'-0"

FOR LOW VOLTAGE EQUIPMENT
LAYOUT ON EAST WALL THIS
ROOM, SEE SHEET E7.

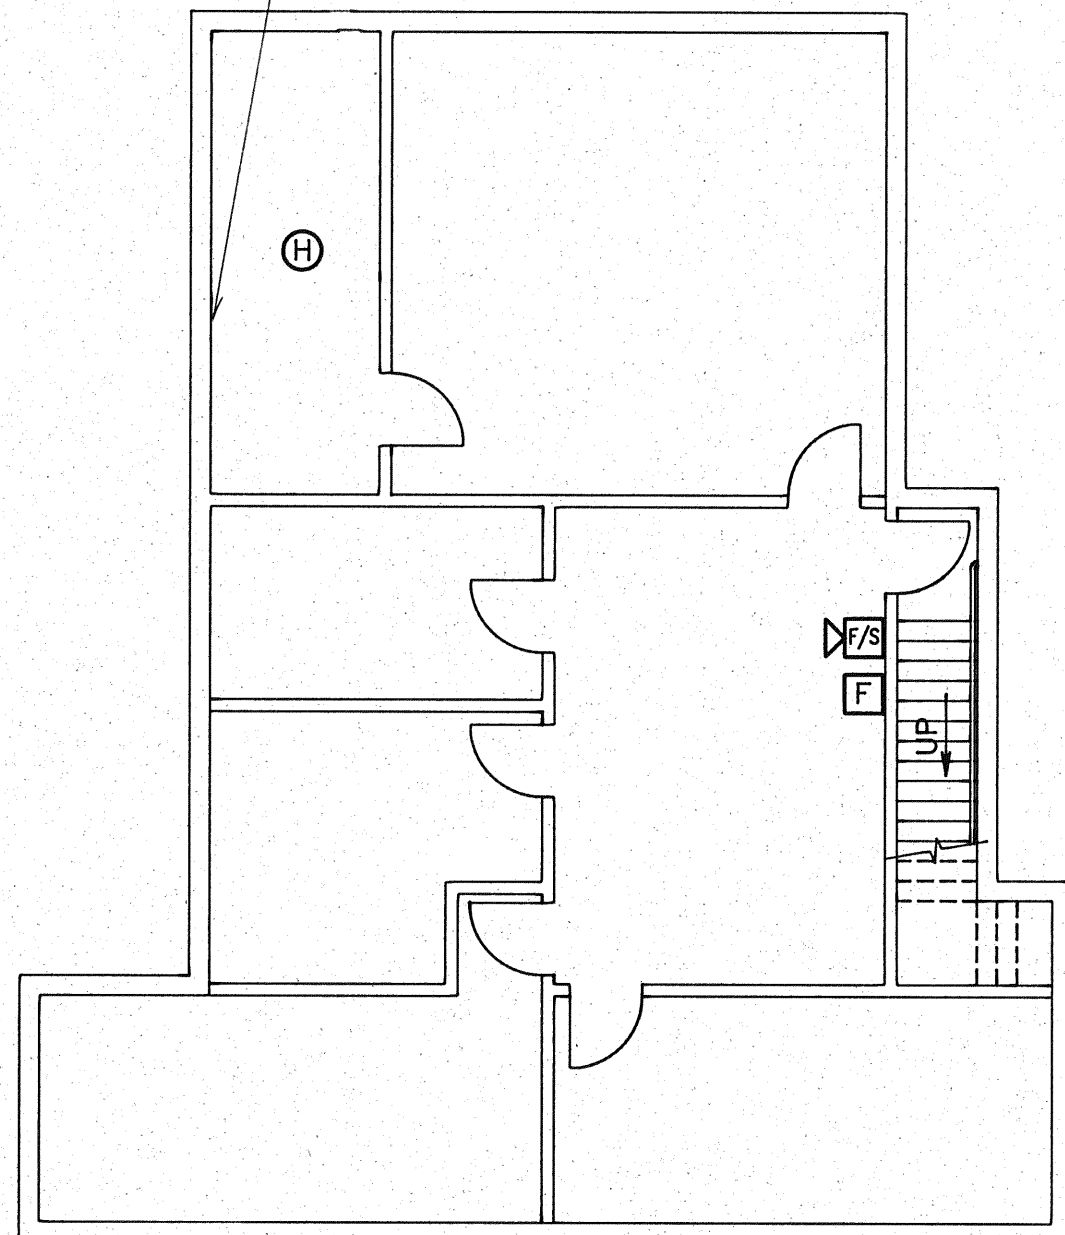

BASEMENT FLOOR PLAN - SYSTEMS

SCALE: 1/8" = 1'-0"

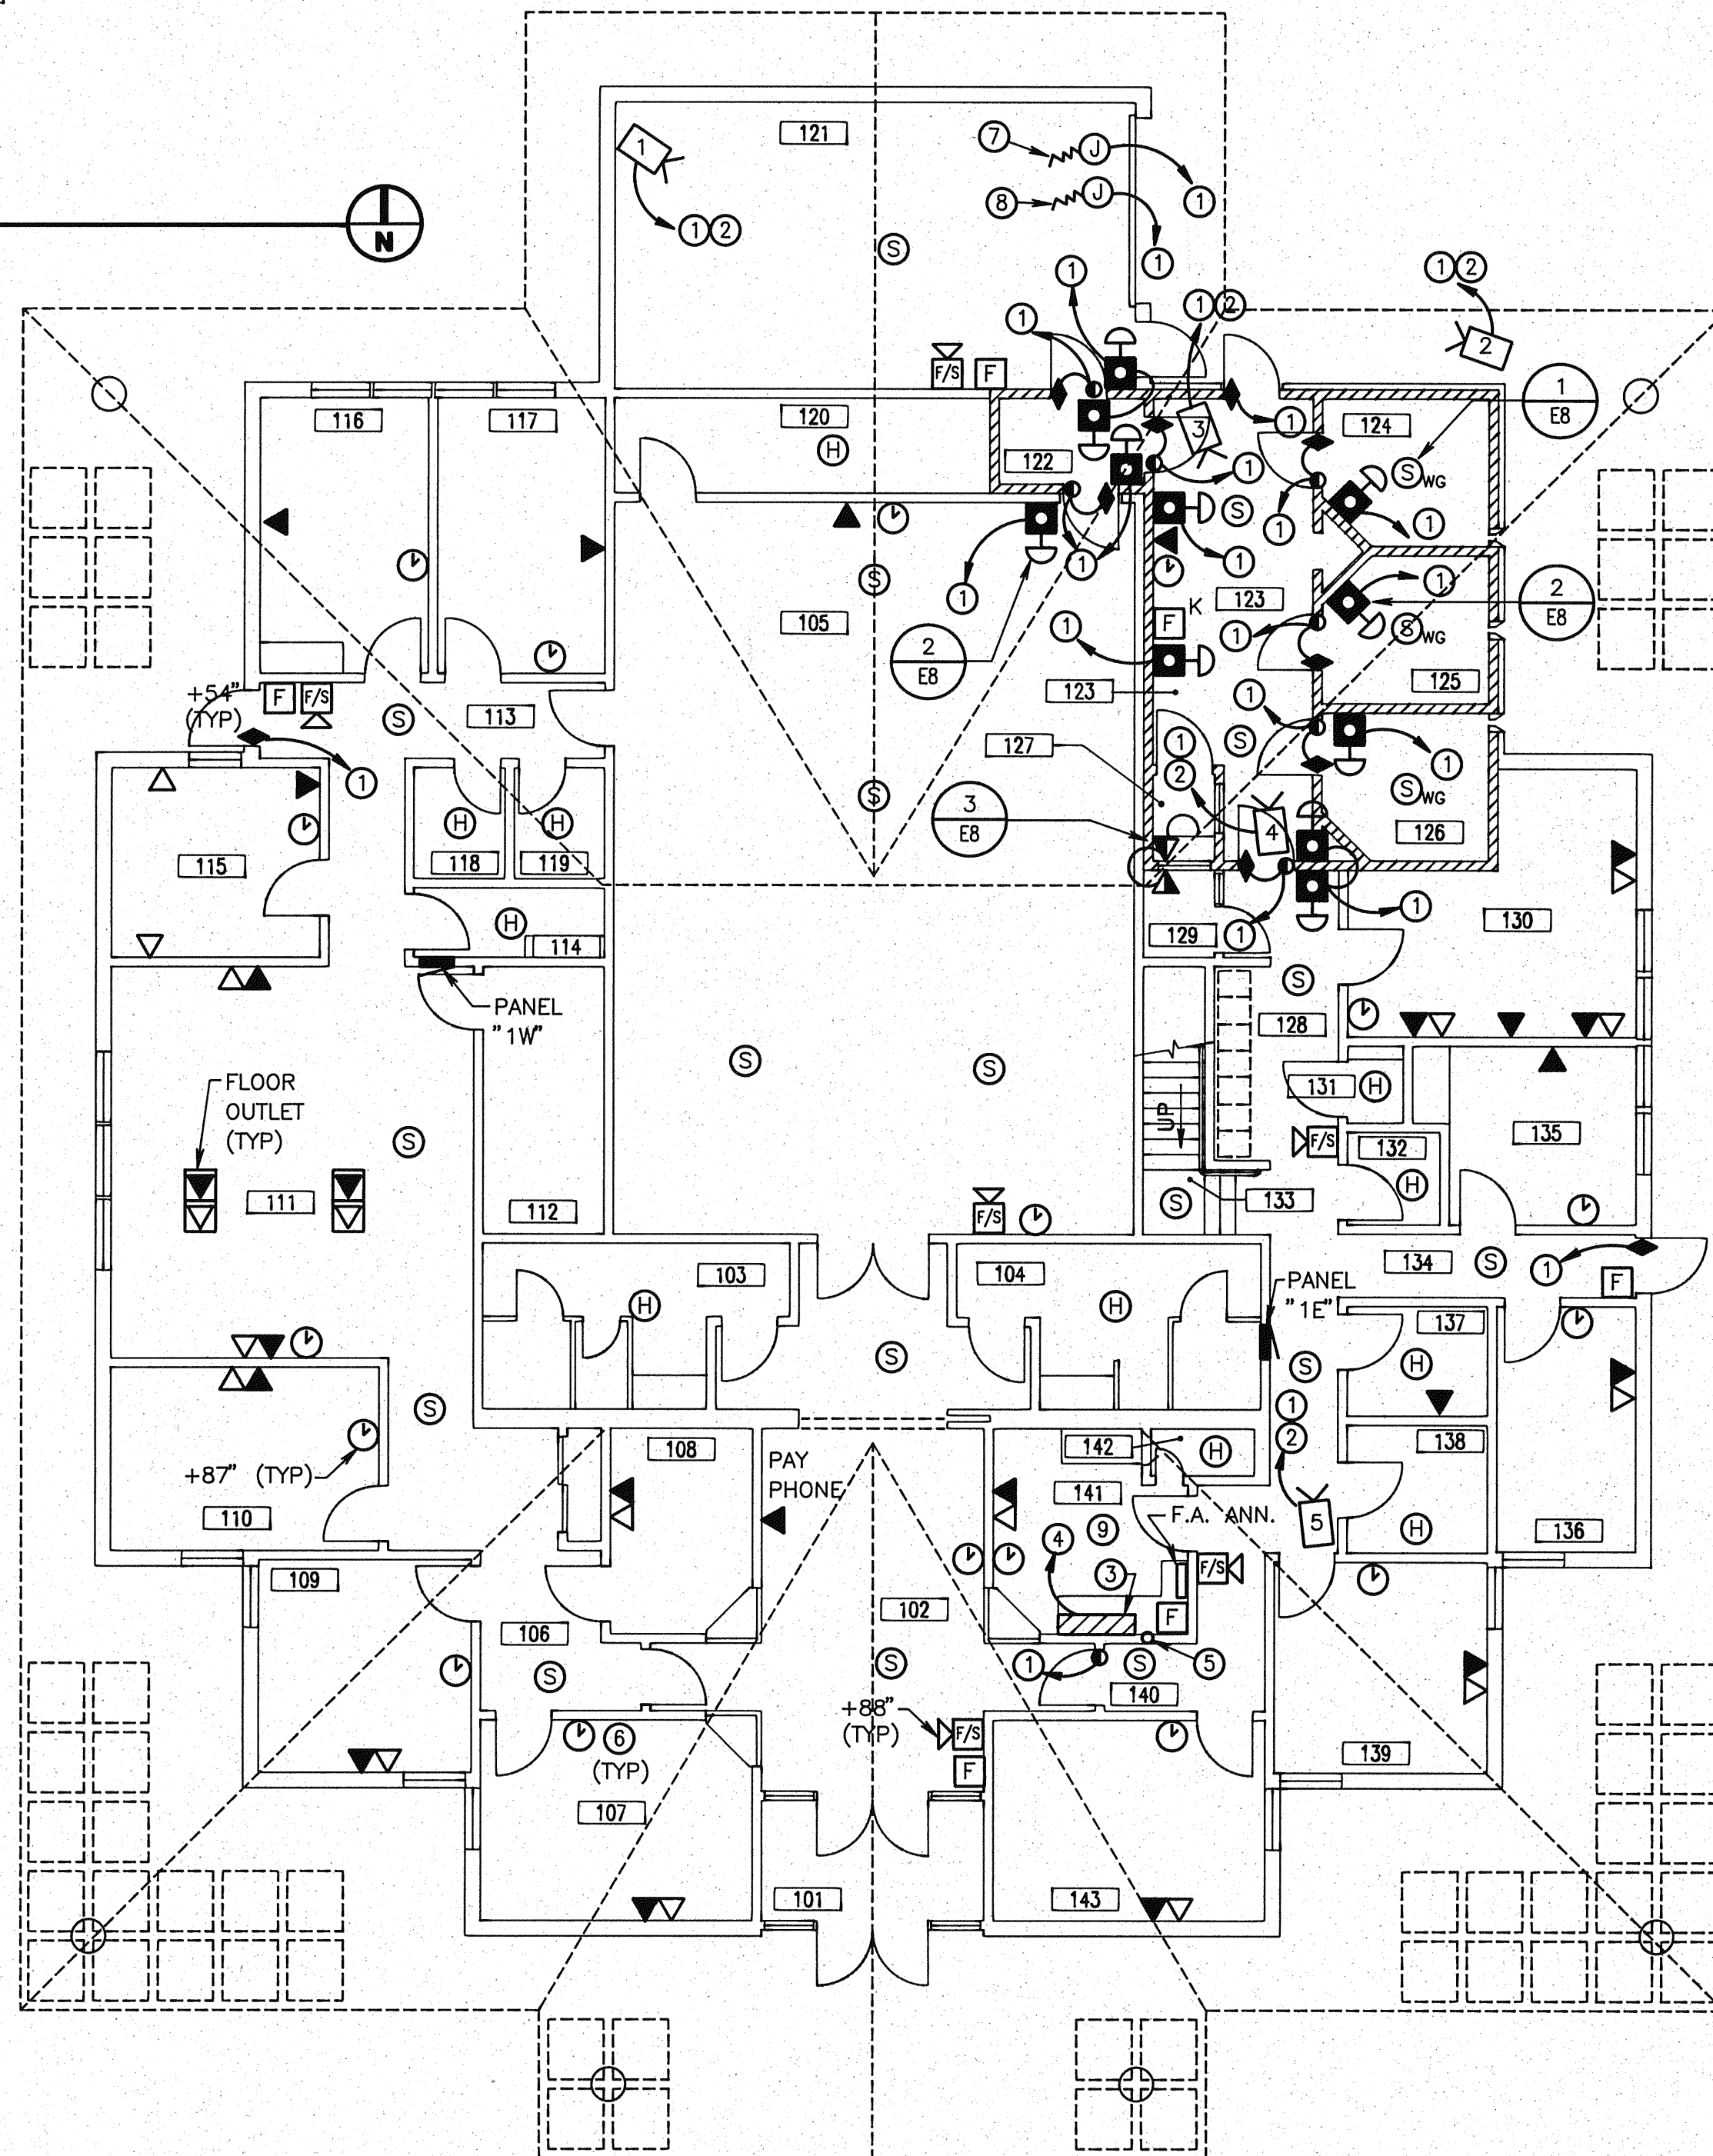

FIRST FLOOR PLAN - SYSTEMS

SCALE: 1/8" = 1'-0"

NOTES:

- 1 ROUTE 3/4" CONDUIT UNDERGROUND TO LOW VOLTAGE EQUIPMENT CABINET IN BASEMENT ELECTRICAL ROOM ("BER").
- 2 ROUTE 3/4" CONDUIT UNDERGROUND TO CAMERA POWER SUPPLY IN "BER".
- 3 SECURITY CONTROL PANEL - VERIFY MOUNTING AND LOCATION.
- 4 ROUTE TWO 3" CONDUITS CONCEALED TO LOW VOLTAGE EQUIPMENT IN "BER".
- 5 PROVIDE 2" CONDUIT FROM RADIO CONSOLE TO +12" ABOVE ROOF FOR ANTENNA CABLE.
- 6 PROVIDE CLOCK RECEPTACLE IN 2" X 4" BOX WITH DEVICE PLATE FOR WALL MOUNT CLOCK. CONNECT CLOCK CIRCUIT TO NEAREST RECEPTACLE CIRCUIT. VERIFY ACTUAL MOUNTING LOCATIONS AND HEIGHT WITH ARCHITECT.
- 7 CONNECT TO OVERHEAD DOOR POSITION SWITCH FURNISHED WITH DOOR OPERATOR.
- 8 CONNECT DOOR OPERATOR CONTROL.
- 9 SEE LARGE SCALE ARCHITECTURAL PLAN FOR DETAILED LAYOUT IN THIS ROOM. INSTALLATION OF SECURITY ELECTRONICS PANELS AND RADIO EQUIPMENT TO BE CLOSELY COORDINATED WITH OWNER/ARCHITECT.