


CITY OF
COLLEGE PLACE
MUNICIPAL
BUILDING

COLLEGE PLACE,
WASHINGTON

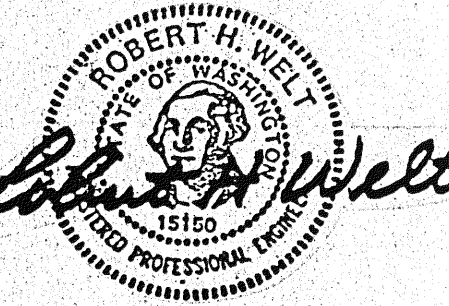


Architects & Engineers

INTEGRUS
ARCHITECTURE

244 West Main Avenue
Spokane, Washington 99201
509/838-8681
FAX 509/838-2194

Mechanical/Electrical Engineers


MW Consulting Engineers
Great Northwest Bldg., Suite 200
222 North Wall Street
Spokane, Washington 99201-0877
509/838-9020
FAX 509/838-1123

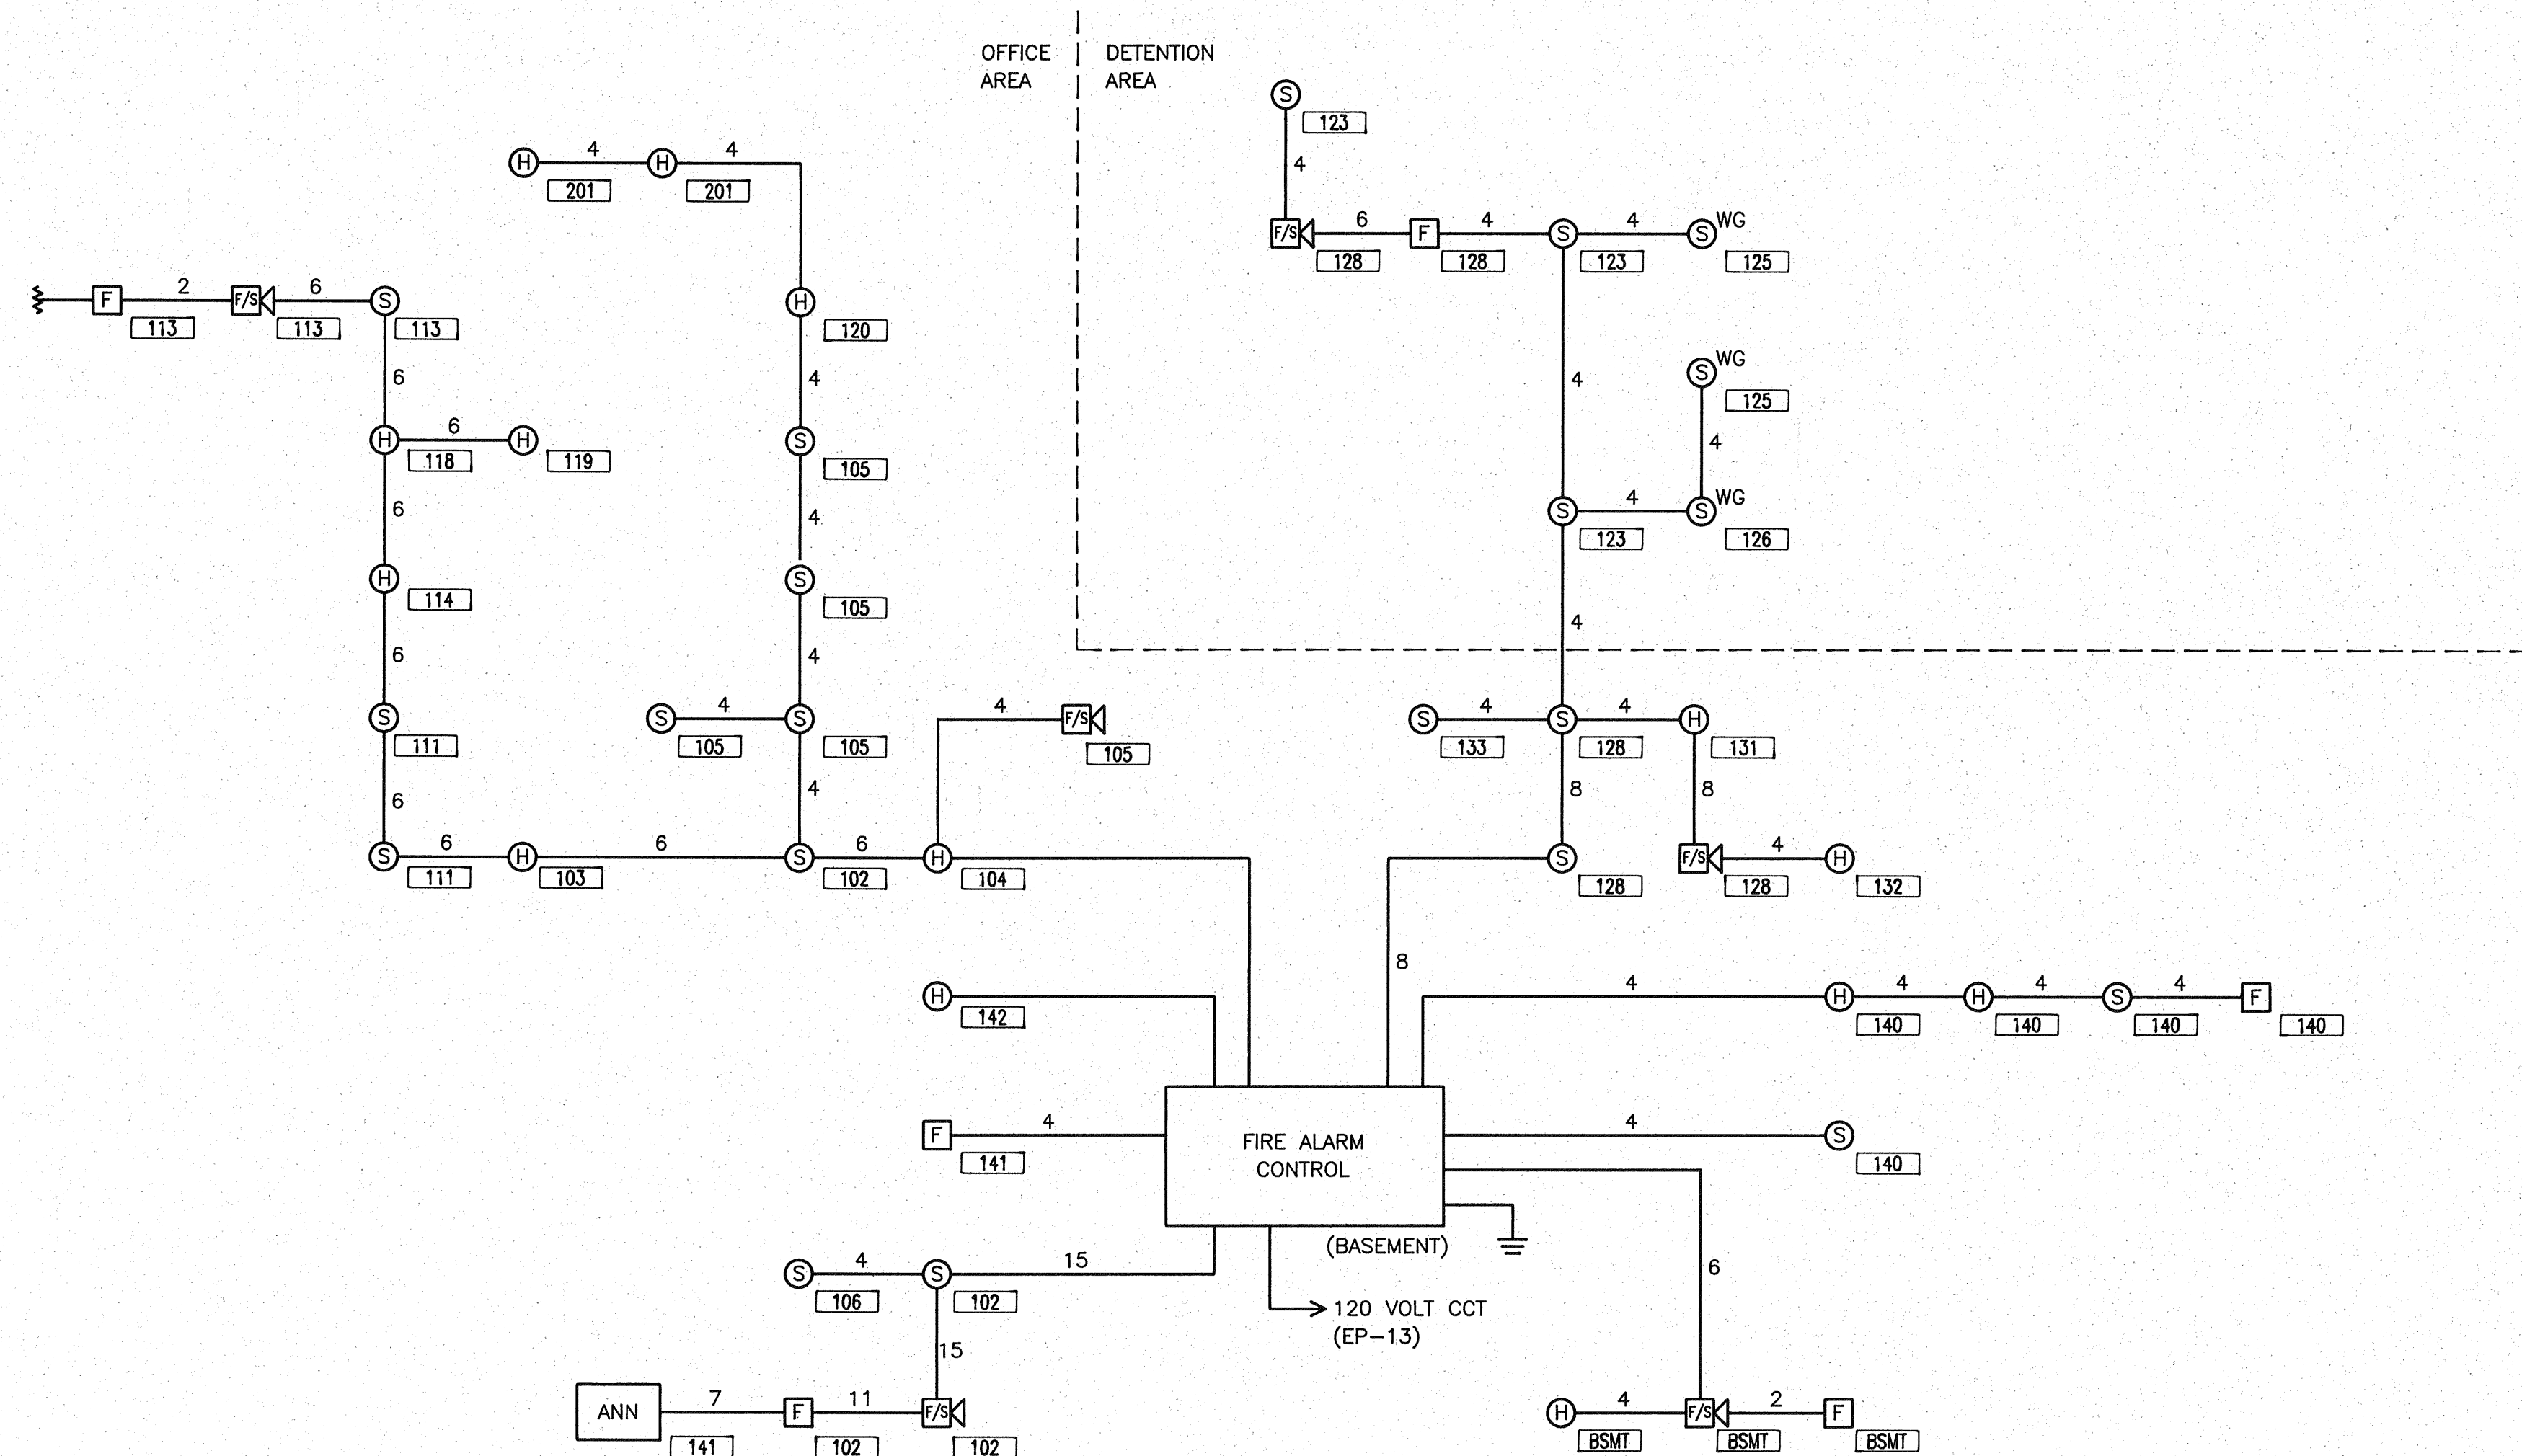

FIRE ALARM SYSTEM RISER DIAGRAM

NOT TO SCALE

1

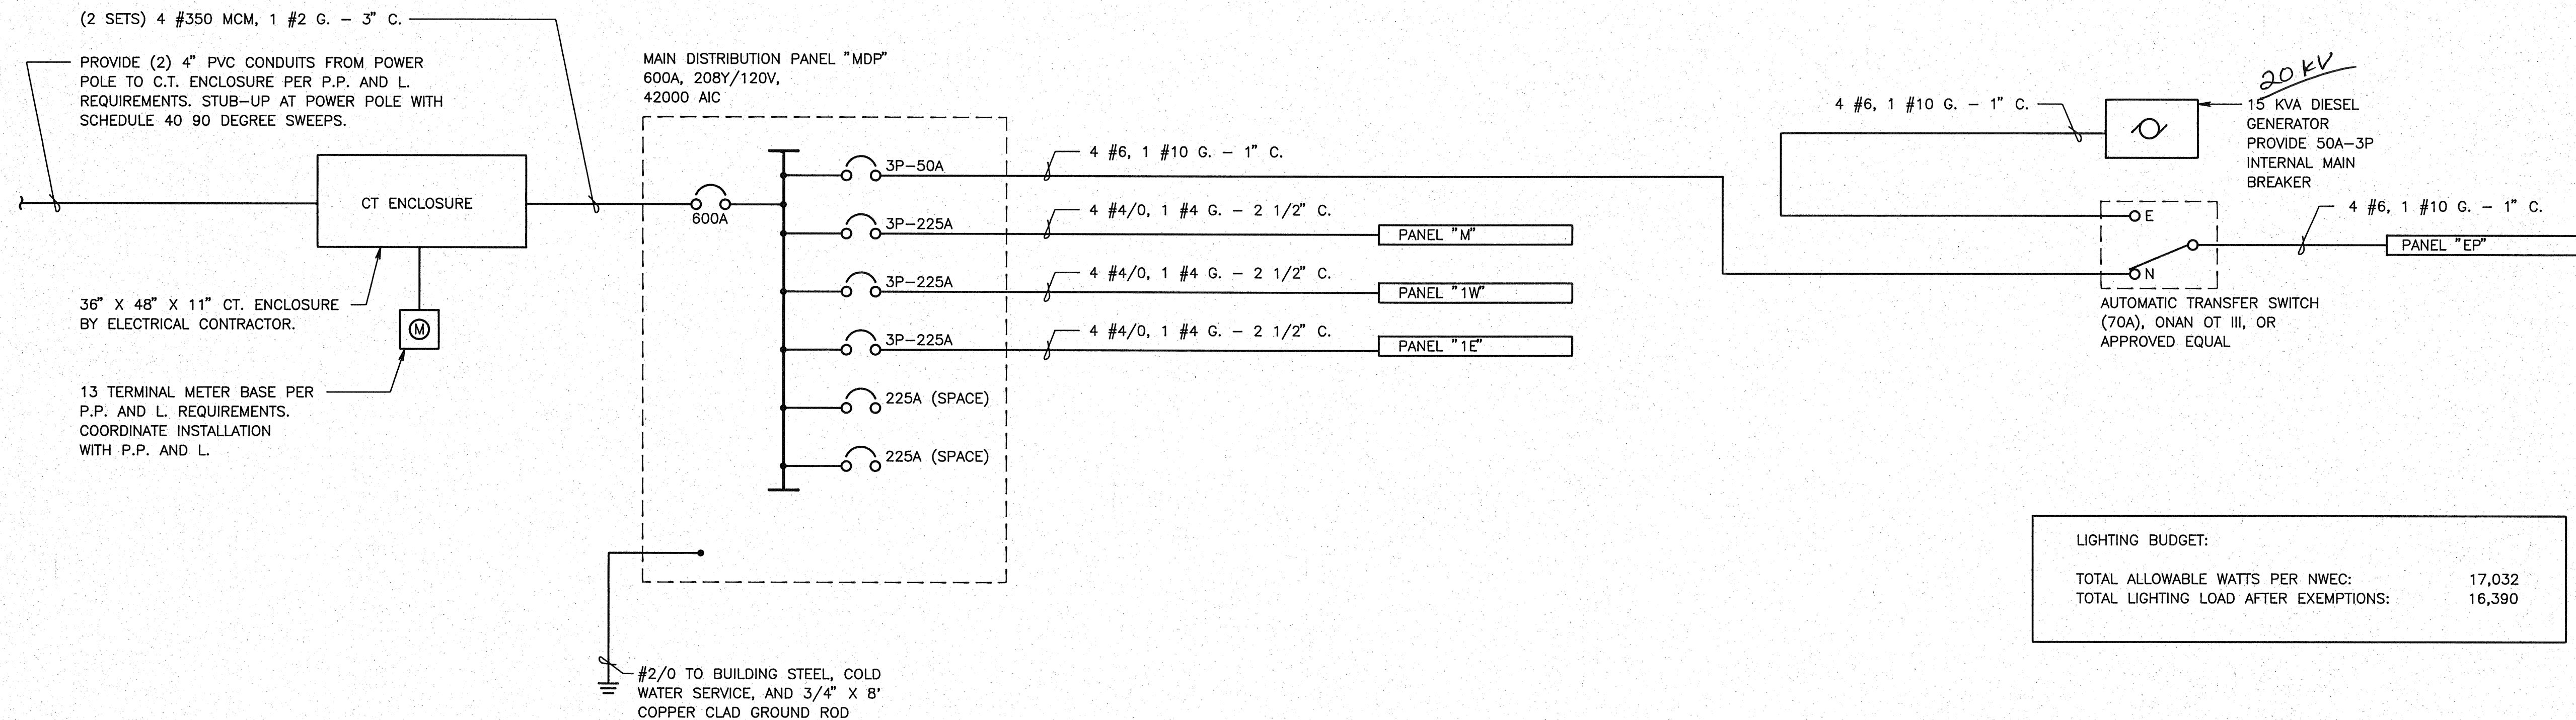

POWER ONE LINE DIAGRAM

NOT TO SCALE

2

Job Number 9119.50
Drawn By DHP
Checked By RHW
Date 9-10-91
Revisions

Sheet Contents
ELECTRICAL
DISORDERS

E6