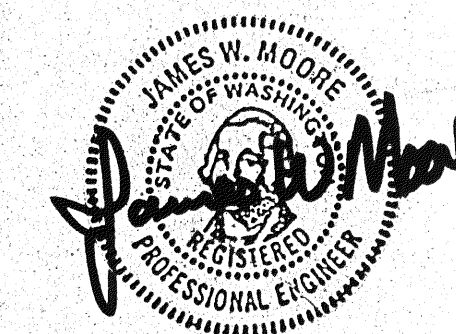


COLLEGE PLACE
WASHINGTON

INTEGRUS
ARCHITECTURE

MW Consulting Engineers
Great Northwest Bldg., Suite 200
222 North Wall Street
Spokane, Washington 99201-08
509/838-9020
FAX 509/838-1123

Job Number 9119.50
 Drawn By ES
 Checked By RDR
 Date 9-18-91
 Revisions _____

Sheet Contents


FLOOR PLAN -

HVAC


M3

- ① 7"x7" UP THRU ROOF W/LOW PROFILE ROOF JACK.
- ② EF-2 IN CEILING SPACE.
- ③ EF-5 IN CEILING SPACE
- ④ 8"Ø ZONE DAMPER
- ⑤ EF-4 IN CEILING SPACE
- ⑥ 4"Ø UP THRU ROOF W/LOW PROFILE ROOF JACK.
- ⑦ EF-6 IN CEILING SPACE.
- ⑧ EF-7 IN CEILING SPACE
- ⑨ WITH 6"Ø UP TO MECHANICAL ROOM (TYP 2)
- ⑩ TO ZONE DAMPERS IN MECHANICAL ROOM.
- ⑪ ADJUST RETURN DIRECTION TO MAINTAIN POSITIVE PRESSURE IN ROOM.

1. COORDINATE DIFFUSER AND GRILLE LOCATIONS WITH ARCHITECTURAL REFLECTED CEILING PLAN.
2. MOUNT THERMOSTATS AT 5'-0" A.F.F. FOR CONTROL OF ZONE DAMPER INDICATED.
3. ROUTE $\frac{3}{8}$ " RL, $\frac{7}{8}$ " RS REFRIGERANT PIPING IN CEILING SPACE BETWEEN COOLING COILS AND CONDENSING UNITS.

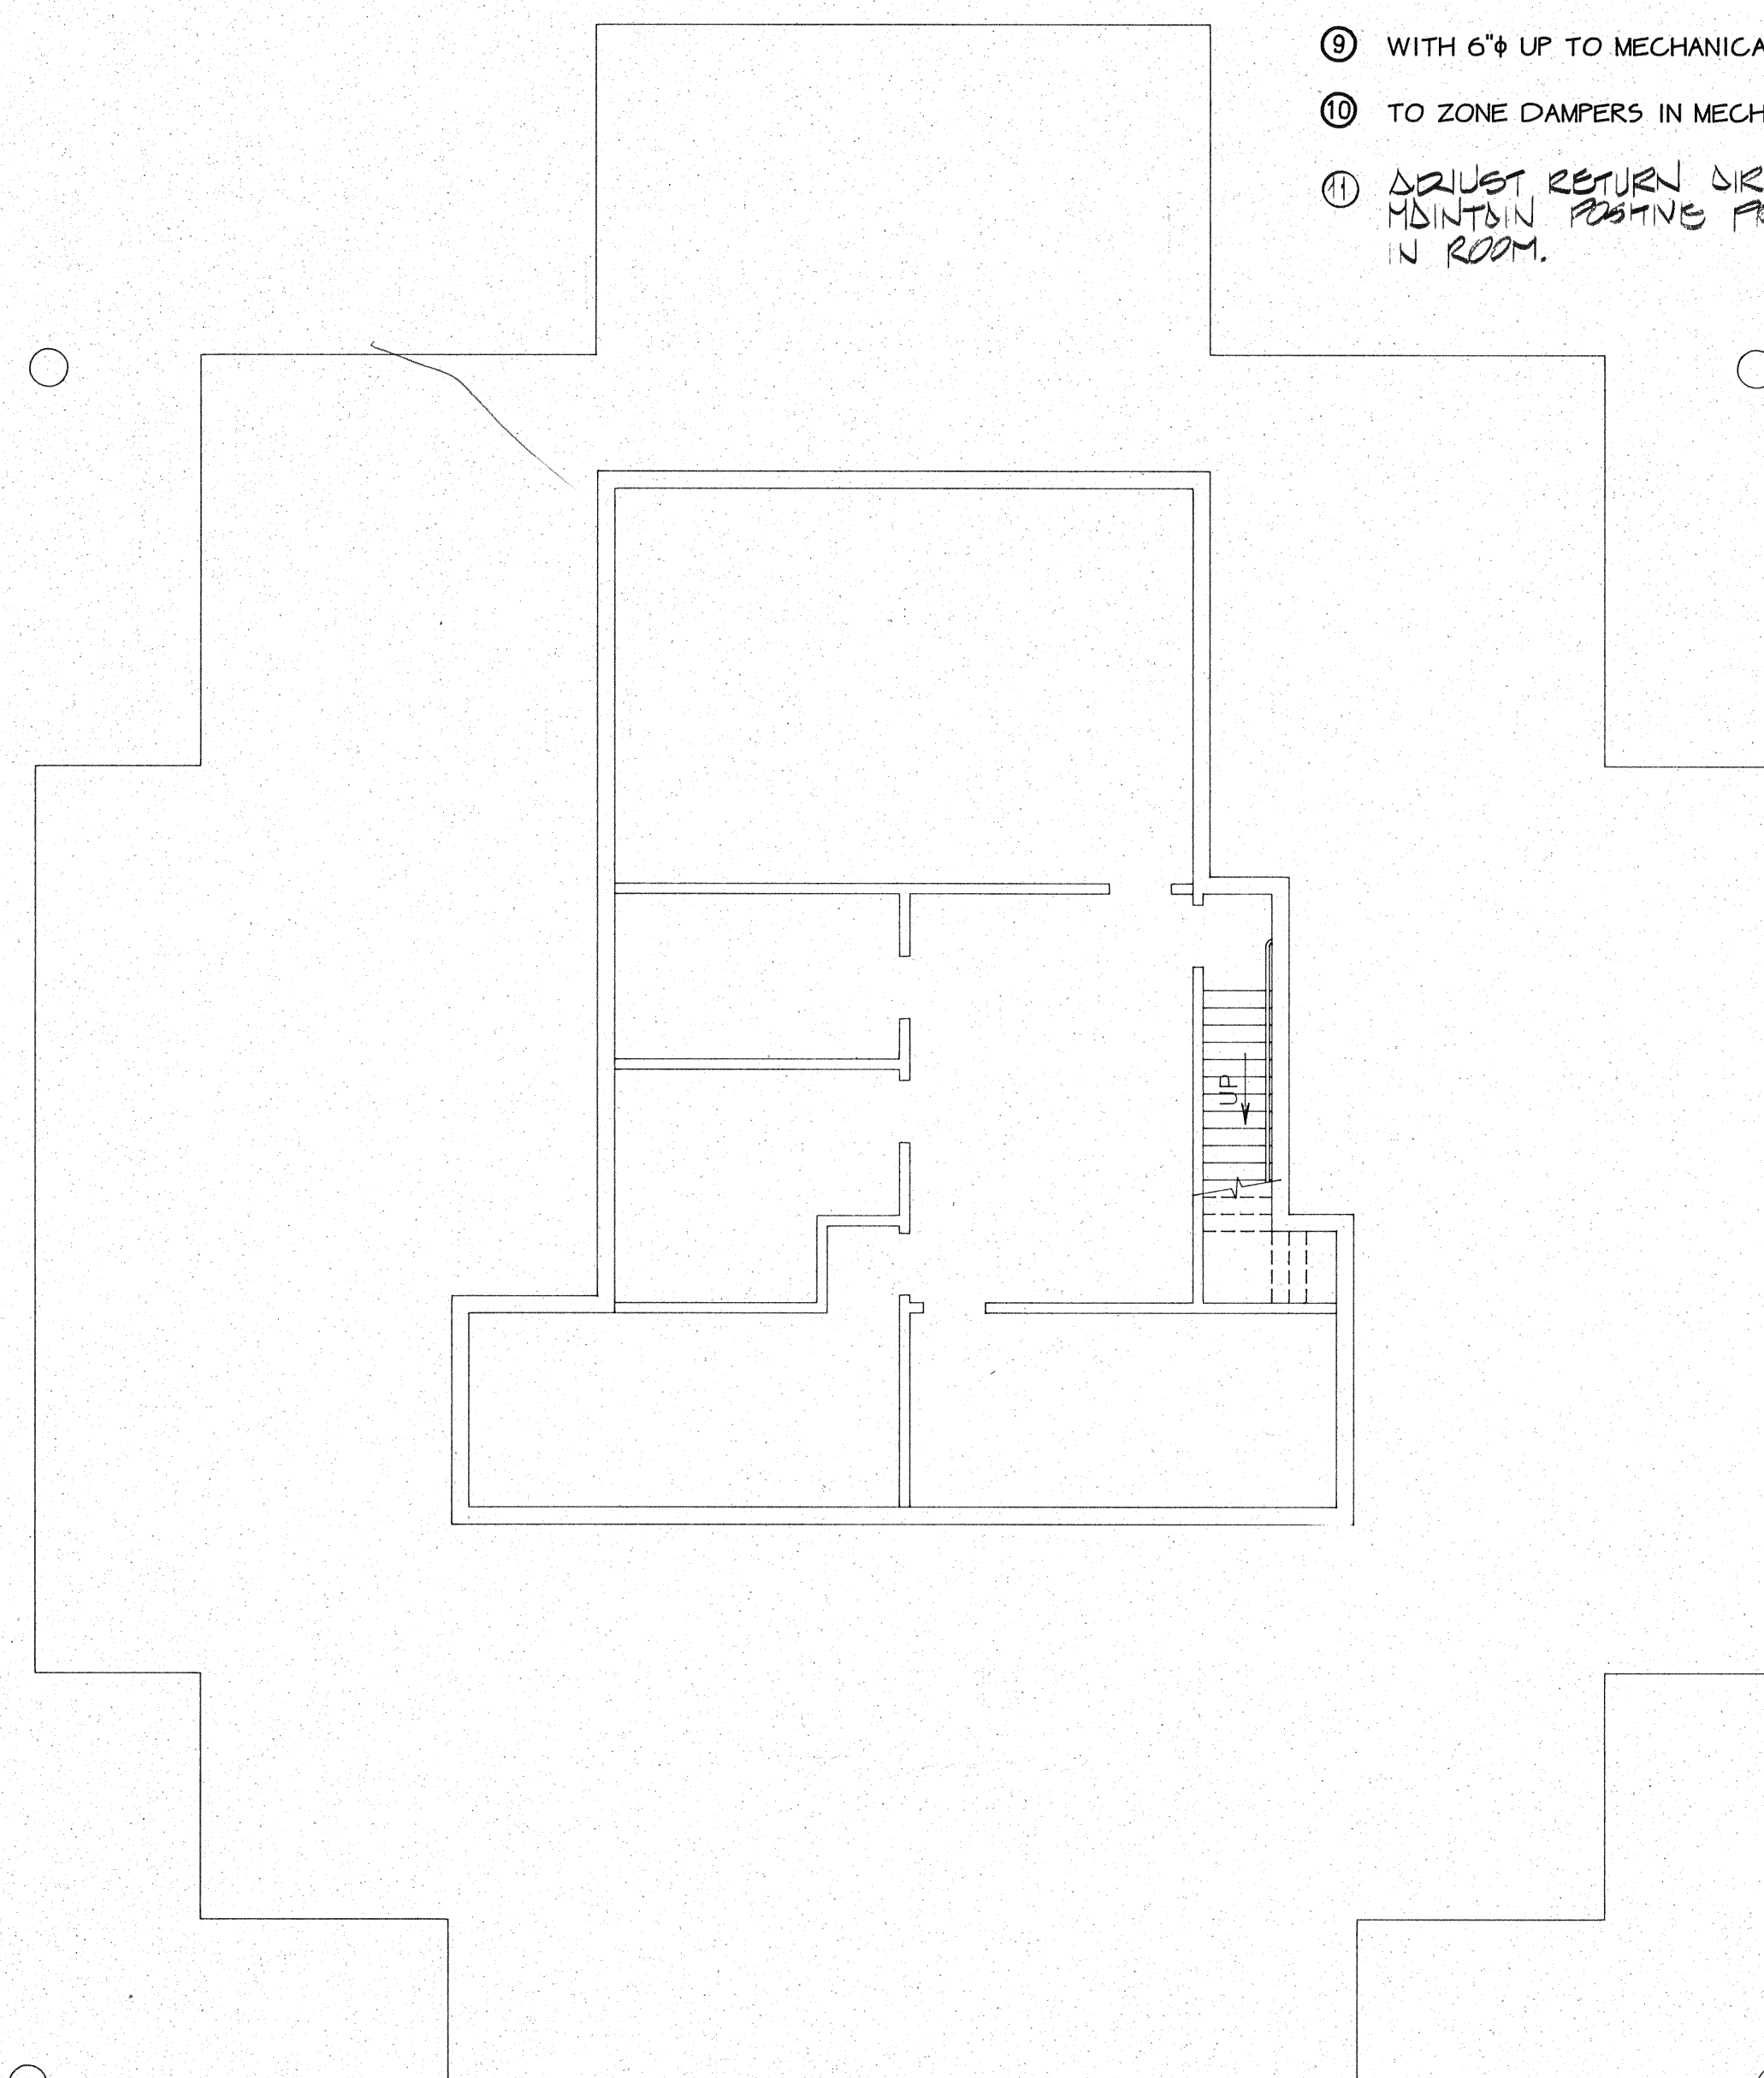

SCALE: 1/8" = 1'-0"

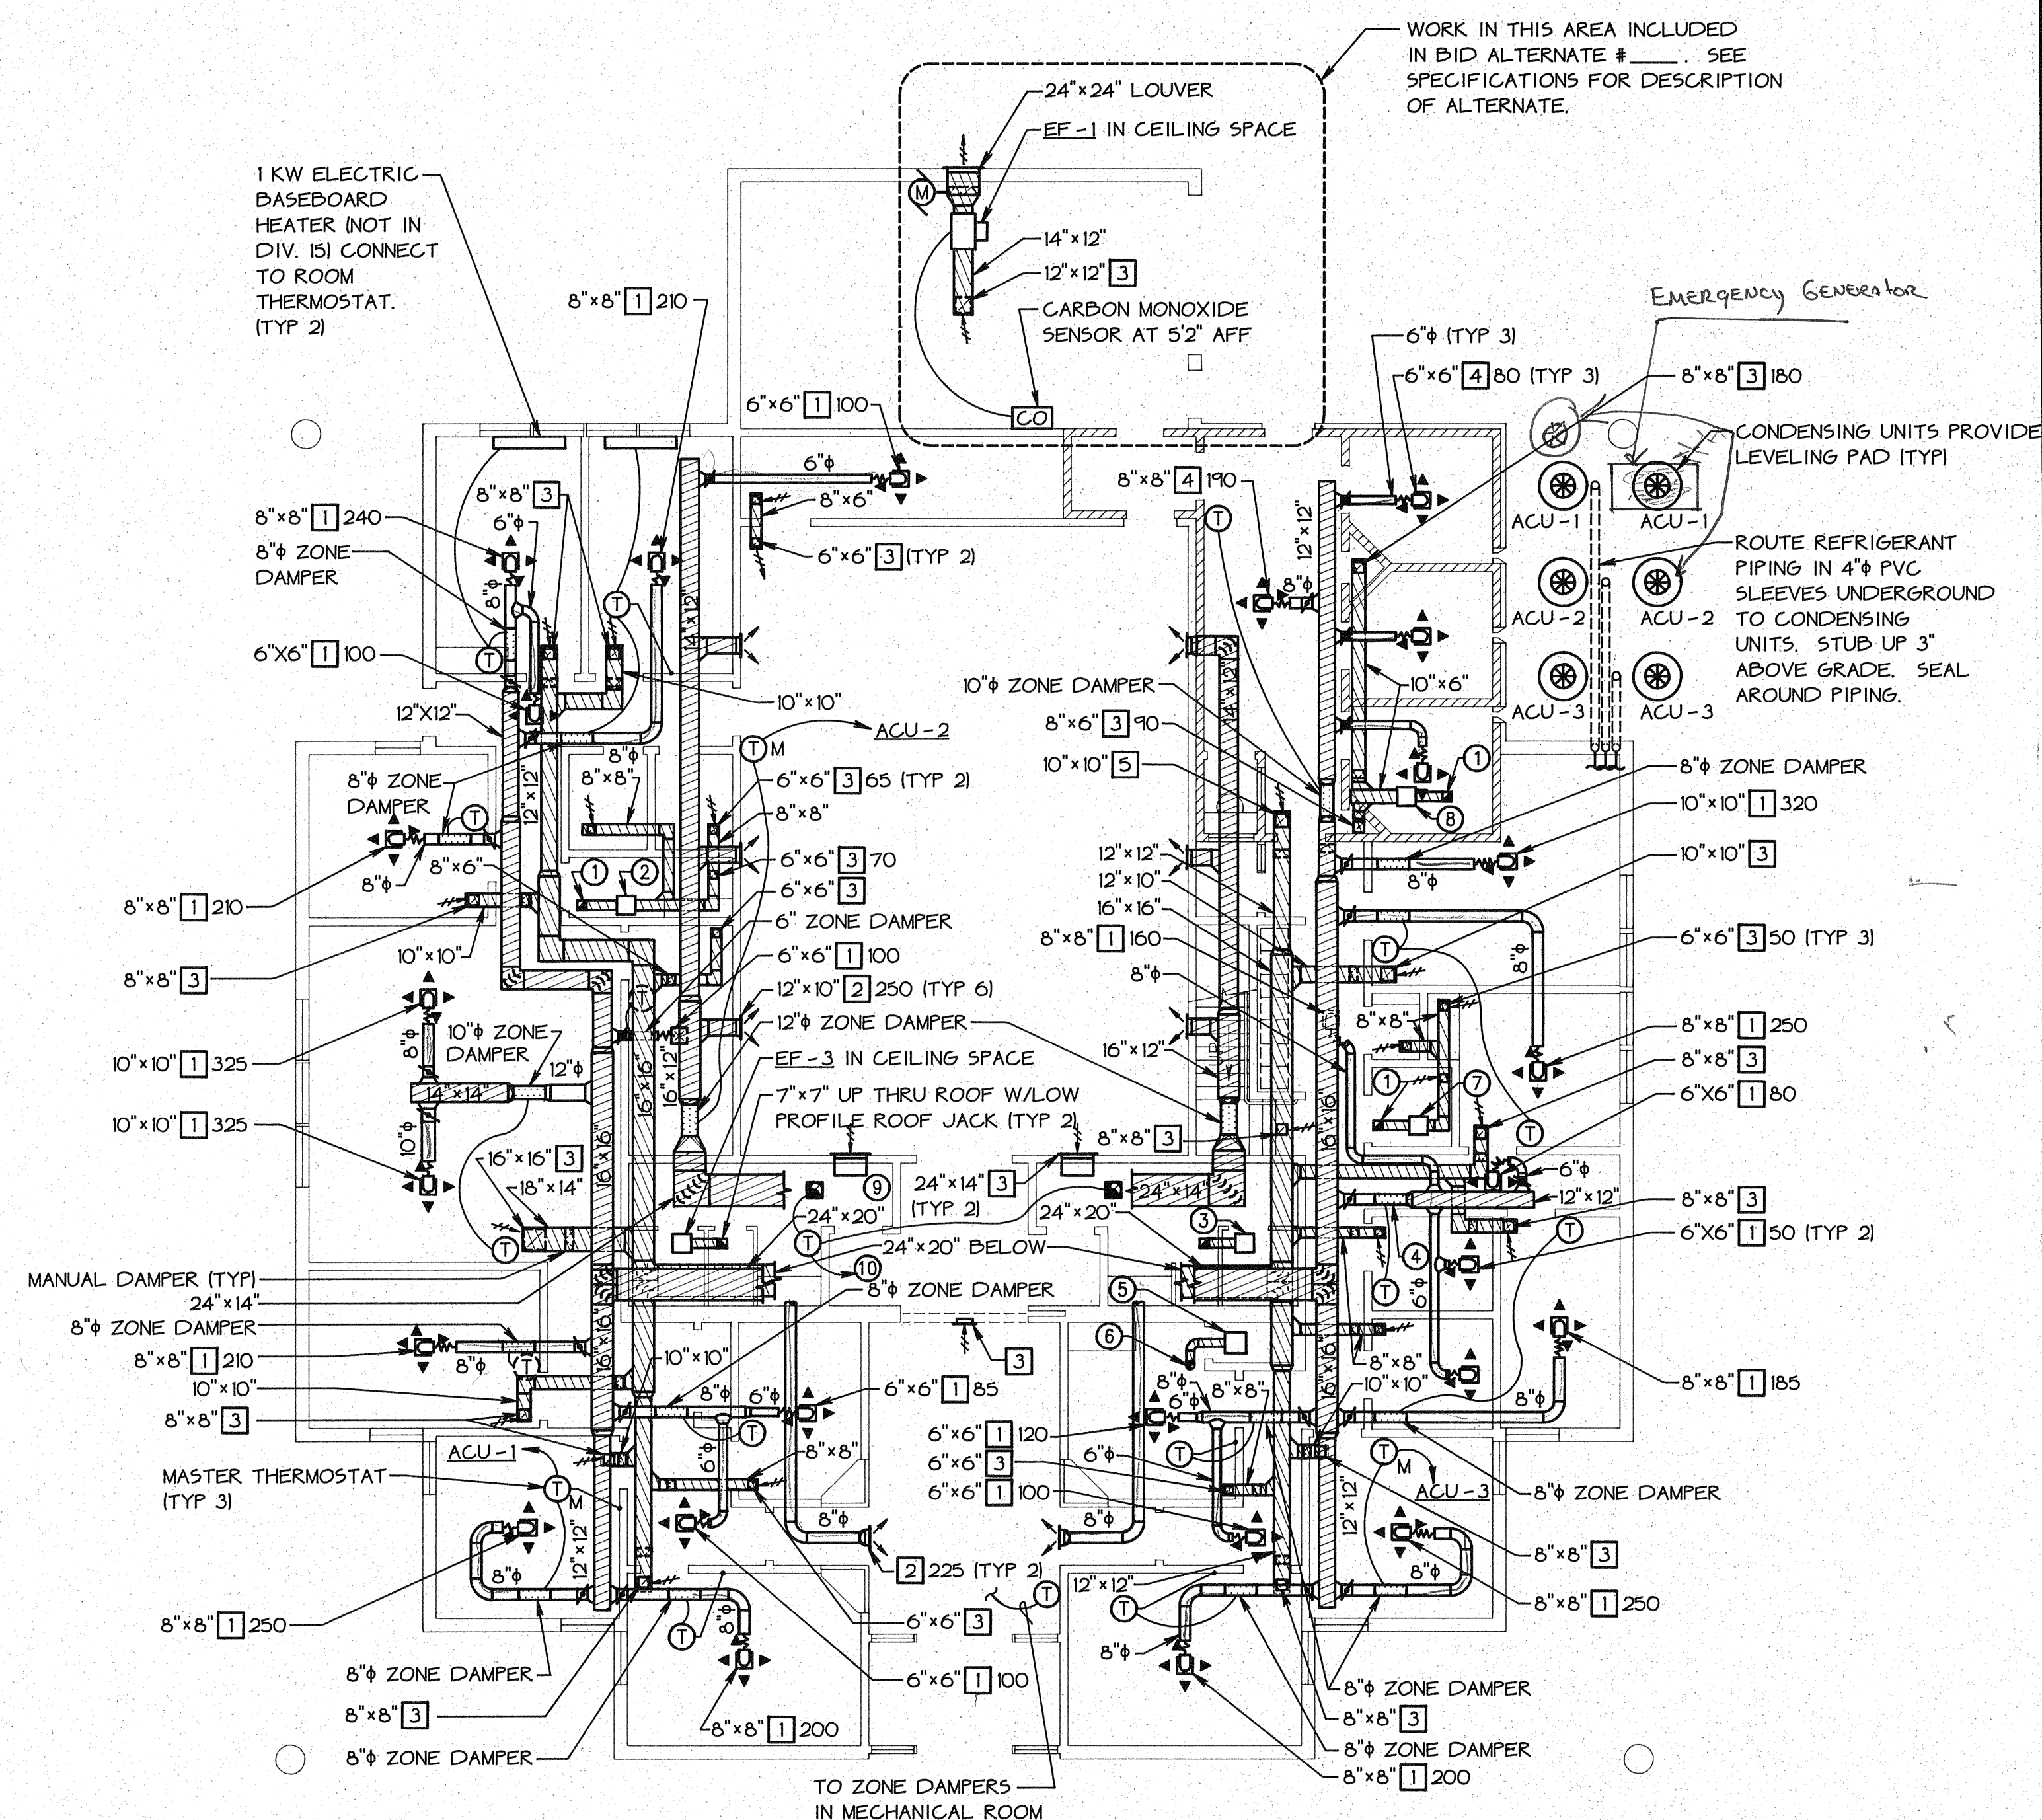

SCALE: 1/8" = 1'-0"

